



**North Donahue Widening Phase 1
City of Auburn, Alabama**

**Addendum 2
September 18, 2026**

The following, as clarifications, corrections or changes to the Contract Documents, will be included into any agreement for the construction of the North Donahue Widening Phase 1 project and must be taken into account in preparing and submitting a Bid for the work. No other provisions or conditions are waived or changed hereby.

Acknowledgment of receipt of this addendum shall be emailed back to the City of Auburn at webengineering@auburnal.gov AND included within the prospective contractor's sealed bid submitted by **11:00 AM on Wednesday, September 23, 2026.**

Changes and Additions

1. Added pay item for the green bike lane striping under 703H000 Specialty Traffic Control Markings
2. Added pay item 640A005 Underground Utility Adjustment
3. Updated plan sheets for utilities

Attachments:

1. Updated Plan Sheets
2. Updated Bid Sheet

I acknowledge receipt of Addendum 2 to the North Donahue Widening Phase 1 project.

(Name)

(Date)



ALDOT ITEM#	TOTAL	UNIT	DESCRIPTION
201A002	12	ACRE	CLEARING & GRUBBING (MAXIMUM ALLOWABLE BID \$4,000 PER ACRE)
206C000	353	SQUARE YARD	REMOVE CONCRETE SIDEWALK
206C001	510	SQUARE YARD	REMOVE CONCRETE PAVEMENT
206D000	498	LINEAR FOOT	REMOVING PIPE
206D001	240	LINEAR FOOT	REMOVING GUARDRAIL
206D003	3,111	LINEAR FOOT	REMOVING CURB AND GUTTER
206E000	13	EACH	REMOVING HEADWALLS
206E008	6	EACH	REMOVING GUARDRAIL END ANCHOR (ALL TYPES)
210A000	23,500	CUBIC YARD	UNCLASSIFIED EXCAVATION
210D021	23,000	CUBIC YARD	BORROW EXCAVATION (LOOSE TRUCKBED MEASUREMENT)(A4 OR BETTER)
230B000	7,000	SQUARE YARD	ROADBED PROCESSING
301B008	11,340	CUBIC YARD	CRUSHED AGGREGATE BASE COURSE, TYPE B, PLANT MIXED
327A020	642	TON	PLANT MIX BITUMINOUS BASE, MIX 1
405A000	4,290	GALLON	TACK COAT
408A051	20,155	SQUARE YARD	PLANING EXISTING PAVEMENT (APPROXIMATELY 0.00" THRU 1.0" THICK)
424A356	3,600	TON	SUPERPAVE BITUMINOUS CONCRETE WEARING SURFACE LAYER, 3/8" MAX. AGG. SIZE MIX, ESAL RANGE C/D (1.5" THICK)
424A364		TON	SUPERPAVE BITUMINOUS CONCRETE UPPER BINDER LAYER, PATCHING, 3/4" MAXIMUM AGGREGATE SIZE MIX ESAL RANGE C/D
424A367		TON	SUPERPAVE BITUMINOUS CONCRETE UPPER BINDER LAYER, LEVELING, 3/4" MAXIMUM AGGREGATE SIZE MIX ESAL RANGE C/D
424B650	5,310	TON	SUPERPAVE BITUMINOUS CONCRETE UPPER BINDER LAYER, 3/4" MAX. AGG. SIZE MIX, ESAL RANGE C/D (2.25" THICK)
424B681	6,475	TON	SUPERPAVE BITUMINOUS CONCRETE LOWER BINDER LAYER, 1" MAX. AGG. SIZE MIX, ESAL RANGE C/D (2.75" THICK)
450A016	328	SQUARE YARD	REINFORCED CEMENT CONCRETE PAVEMENT, 12 INCHES THICK
530A000	105	LINEAR FOOT	15" ROADWAY PIPE (CLASS 3 R.C.)
530A001	1,339	LINEAR FOOT	18" ROADWAY PIPE (CLASS 3 R.C.)
530A002	3,281	LINEAR FOOT	24" ROADWAY PIPE (CLASS 3 R.C.)
530A003	288	LINEAR FOOT	30" ROADWAY PIPE (CLASS 3 R.C.)
530A006	57	LINEAR FOOT	48" ROADWAY PIPE (CLASS 3 R.C.)
530A033	25	LINEAR FOOT	12" ROADWAY PIPE (CLASS 3 R.C.)
600A000	1	LS	MOBILIZATION
630A001	2,086	LINEAR FOOT	STEEL BEAM GUARDRAIL, CLASS A, TYPE 2
610C000	120	TON	LOOSE RIPRAP, CLASS 1
610D003	200	SQUARE YARD	FILTER BLANKET, GEOTEXTILE
614A000	10	CUBIC YARD	SLOPE PAVING
618A000	6,892	SQUARE YARD	CONCRETE SIDEWALK, 4" THICK
618A001	180	SQUARE YARD	CONCRETE DRIVEWAY, 6" THICK
618C001	37	SQUARE FOOT	DETECTABLE WARNING SURFACE
618D000	384	SQUARE YARD	CURB RAMP
621C015	29	EACH	INLETS, TYPE S1 OR S3 (1 WING)
621C017	4	EACH	INLETS, TYPE S1 OR S3 (2 WING)
622A002	6	EACH	MANHOLE COVERS RESET (SANITARY)
623B000	1,684	LINEAR FOOT	CONCRETE CURB, TYPE N
623B001	379	LINEAR FOOT	CONCRETE CURB, TYPE N SPECIAL
623C003	17,430	LINEAR FOOT	COMBINATION CURB AND GUTTER, TYPE C (MODIFIED)
630C003	3	EACH	GUARDRAIL END ANCHOR, TYPE 13
630C077	11	EACH	GUARDRAIL END ANCHOR, TYPE 8 (MASH)
630C080	3	EACH	GUARDRAIL END ANCHOR, TYPE 20 (MASH)
641A514	23	LINEAR FOOT	1" COPPER WATER SERVICE LINE LAID
641A518	106	LINEAR FOOT	2" COPPER WATER SERVICE LINE LAID
641A614	58	LINEAR FOOT	8" DUCTILE IRON WATER MAIN LAID
641A616	33	LINEAR FOOT	10" DUCTILE IRON WATER MAIN LAID
641A622	1,564	LINEAR FOOT	16" DUCTILE IRON WATER MAIN LAID
641A692	278	LINEAR FOOT	16" DUCTILE IRON WATER MAIN LAID (RESTRAINED JOINT)
641E500	6	EACH	FIRE HYDRANT RESET
641F500	209	LINEAR FOOT	FIRE HYDRANT EXTENSION
641Q500	4	EACH	WATER METER AND BOX RESET
641S500	9	EACH	VALVE BOX RESET

ALDOT ITEM#	TOTAL	UNIT	DESCRIPTION
650B000	3,590	CUBIC YARD	TOPSOIL FROM STOCKPILES
652A100	7	ACRE	SEEDING
654A001	1,000	SQUARE YARD	SOLID SODDING (BERMUDA)
656A010	7	ACRE	MULCHING
665A000	14	ACRE	TEMPORARY SEEDING
665J002	17,762	LINEAR FOOT	SILT FENCE
665P005	33	EACH	INLET PROTECTION, STAGE 3 OR 4
665Q002	1,600	LINEAR FOOT	WATTLE
680A001	1	LUMP SUM	GEOMETRIC CONTROLS
698A000	1	LS	CONSTRUCTION FUEL (MAXIMUM BID LIMITED TO \$357,000)
701A227	5.6	MILE	SOLID WHITE, CLASS 2, TYPE A TRAFFIC STRIPE (5" WIDE)
701A230	3.2	MILE	SOLID YELLOW, CLASS 2, TYPE A TRAFFIC STRIPE (5" WIDE)
701A239	2.5	MILE	BROKEN WHITE, CLASS 2, TYPE A TRAFFIC STRIPE (5" WIDE)
701A244	0.2	MILE	BROKEN YELLOW, CLASS 2, TYPE A TRAFFIC STRIPE (5" WIDE)
701B207	6,473	LINEAR FOOT	DOTTED WHITE, CLASS 2, TYPE A TRAFFIC STRIPE (5" WIDE)
701C000	0.11	MILE	BROKEN TEMPORARY TRAFFIC STRIPE
701C001	4.74	MILE	SOLID TEMPORARY TRAFFIC STRIPE
703A002	42,875	SQUARE FEET	TRAFFIC CONTROL MARKINGS, CLASS 2, TYPE A
703B002	105	SQUARE FEET	TRAFFIC CONTROL LEGENDS, CLASS 2, TYPE A
703D001	3,500	SQUARE FEET	TEMPORARY TRAFFIC CONTROL MARKINGS
703E001	4,375	SQUARE FEET	TEMPORARY TRAFFIC CONTROL LEGENDS
705A000	866	EACH	PAVEMENT MARKERS, CLASS A-H, TYPE 1A
705A030	480	EACH	PAVEMENT MARKERS, CLASS A-H, TYPE 2C
705A032	470	EACH	PAVEMENT MARKERS, CLASS A-H, TYPE 1B
705A037	630	EACH	PAVEMENT MARKERS, CLASS A-H, TYPE 2D
705A038	1,200	EACH	PAVEMENT MARKERS, CLASS A-H, TYPE 2E
730A000	1	LUMP SUM	TRAFFIC SIGNAL AND COMPONENTS FOR INTERSECTION
730C000	1	LUMP SUM	FURNISHING AND INSTALLING TRAFFIC CONTROL UNIT
730E000	4	EACH	METAL TRAFFIC SIGNAL POLE FOUNDATION
730F000	2	EACH	METAL TRAFFIC SIGNAL POLE WITH 80' MAST ARM ASSEMBLY
730F001	2	EACH	METAL TRAFFIC SIGNAL POLE WITH 90' MAST ARM ASSEMBLY
730K001	2	EACH	TRAFFIC SIGNAL JUNCTION BOX, TYPE S1
730K002	4	EACH	TRAFFIC SIGNAL JUNCTION BOX, TYPE S2
730L003	50	LINEAR FOOT	1", NON-METALLIC, CONDUIT
730L004	50	LINEAR FOOT	2", METALLIC, CONDUIT
730L005	1,475	LINEAR FOOT	2", NON-METALLIC, CONDUIT
730N000	4	EACH	LUMINAIRE EXTENSION ASSEMBLY, 12 FEET
730P022	24	EACH	VEHICULAR SIGNAL HEAD, 12 INCH, 3 SECTION, TYPE LED
730Q005	8	EACH	MISCELLANEOUS EQUIPMENT, PEDESTAL POLE AND FOUNDATION
730R041	1	EACH	CONTROLLER ASSEMBLY, TYPE NEMA, 16 CHANNELS
730T010	1	EACH	ELECTRICAL POWER SERVICE ASSEMBLY WITH WOOD POLE
730T022	1	EACH	UNINTERRUPTABLE POWER SUPPLY SYSTEM, MANAGED
730U015	1	LUMP SUM	VIDEO DETECTION SYSTEM
730Y100	2	LS	RELOCATION OF PEDESTAL POLE AND FOUNDATION WITH ILLUMINATED SCHOOL ZONE SIGN
730Y180	2	LS	FURNISHING AND INSTALLING PEDESTALL POLE AND FOUNDATION WITH ILLUMINATED SCHOOL ZONE SIGN
740A000	1	LUMP SUM	TRAFFIC CONTROL FOR CONSTRUCTION WORK ZONES (INCLUDING BUT NOT LIMITED TO CONSTRUCTION SIGNS, CHANNELIZING DRUMS, CONES, 2 PORTABLE CHANGEABLE MESSAGE SIGNS (TYPE 2))
740B000	360	SQUARE FEET	CONSTRUCTION SIGNS
740D000	280	EACH	CHANNELIZING DRUMS
740H000	270	SQUARE FEET	PERMANENT SIGNS
740G000	10	EACH	BARRICADES, TYPE 1, (PORTABLE, 24" WIDE)
741C010	2	EACH	PORTABLE CHANGEABLE SEQUENTIAL ARROW AND CHEVRON SIGN UNIT
742A001	2	EACH	PORTABLE CHANGEABLE MESSAGE SIGN, TYPE 2
750Z220	1	LUMP SUM	ROADWAY LIGHTING
756A028	685	LINEAR FOOT	6" ELECTRICAL CONDUIT, 1 LINE, TYPE S INSTALLATION
640A005	895	LINEAR FOOT	UNDERGROUND UTILITY ADJUSTMENT (16" WATER AND ASSOCIATED APPURTENANCES INCLUDING MAIN LINE VALVES)



PROJECT NO. 2447 ALTON ROAD, STE 101
24052 BIRMINGHAM, AL 35210
CONTACT: Lee Tharp
Tel + 334.315.0239
AUBURN, ALABAMA 36830
PHONE: (334) 501-3000; FAX: (334) 501-7284
These drawings and design intent are the sole property of KADRE, LLC. which may not be reproduced without written permission

ENGINEERING SERVICES




QUANTITIES SHEET

CITY OF AUBURN
NORTH DONAHUE DRIVE WIDENING

REVISIONS				
NO.	CHECK	DATE	DESCRIPTION	
1		9/18/2026	ADDENDUM #1	
2		9/18/2026	ADDENDUM #2	

DRAWN	WCW
CHECKED	BLH
DATE	09/18/2026
SCALE	N.T.S.
SHEET NO.	C0.3

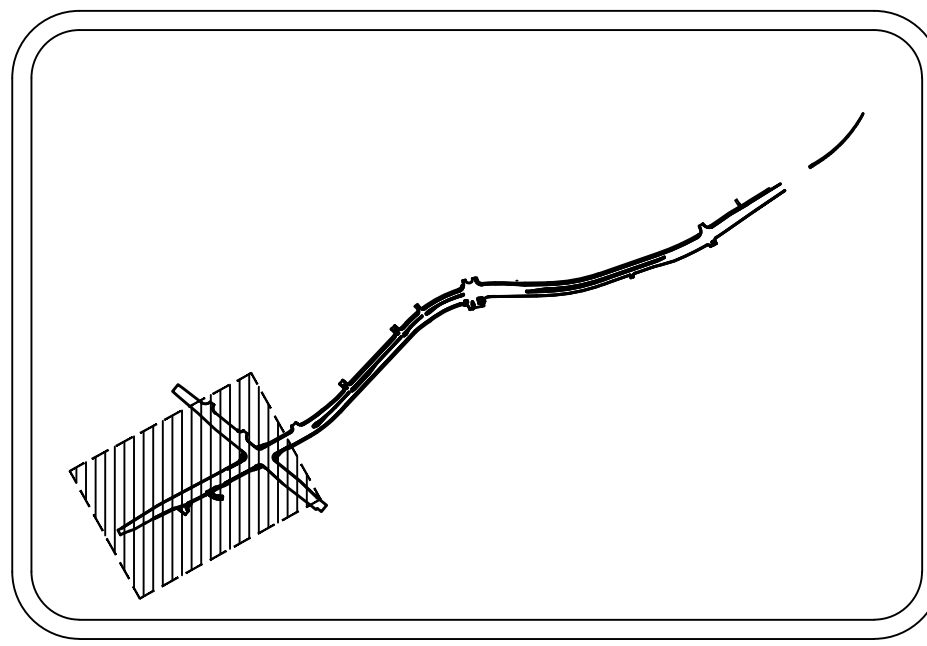


SITE KEY MAP
N.T.S.

THRUST RESTRAINT TABLES					
TABLE 22 External Thrust Restraint for Bends and Dead Ends (Linear Feet of Restraint Required on each Side of the Fitting along the Main Line) WRM Department Design and Construction Manual, Auburn, Alabama					
Main Size, Inches	Fitting				
	Dead End, or (Valve)	90°	45°	22.5°	11.25°
4	42	28	12	6	3
6	58	39	16	8	4
8	76	50	21	10	5
10	77	51	21	10	5
12	91	59	25	12	6
16	110	90	36	17	9

TABLE 23 External Thrust Restraint for Cut-In Tees on Existing Mains (Linear Feet of Restraint Required along the Branch Line Only) WRM Department Design and Construction Manual, Auburn, Alabama					
Branch Size, Inches	Existing Main Size				
	4	6	8	10	12
4	42	39	37	34	31
6	61	58	55	52	49
8	82	79	76	73	69
10	-	98	94	91	87
12	-	118	114	111	106

TABLE 24 External Thrust Restraint for Tees on Proposed Mains (Linear Feet of Restraint Required along the Branch Line in Addition to 20-feet of Restraint on Both Sides of the Tee along the Main Line) WRM Department Design and Construction Manual, Auburn, Alabama					
Branch Size, Inches	Main Size				
	4	6	8	10	12
4	14	1	1	1	1
6	41	30	20	9	1
8	67	57	48	38	29
10	-	79	71	62	53
12	-	102	94	86	77

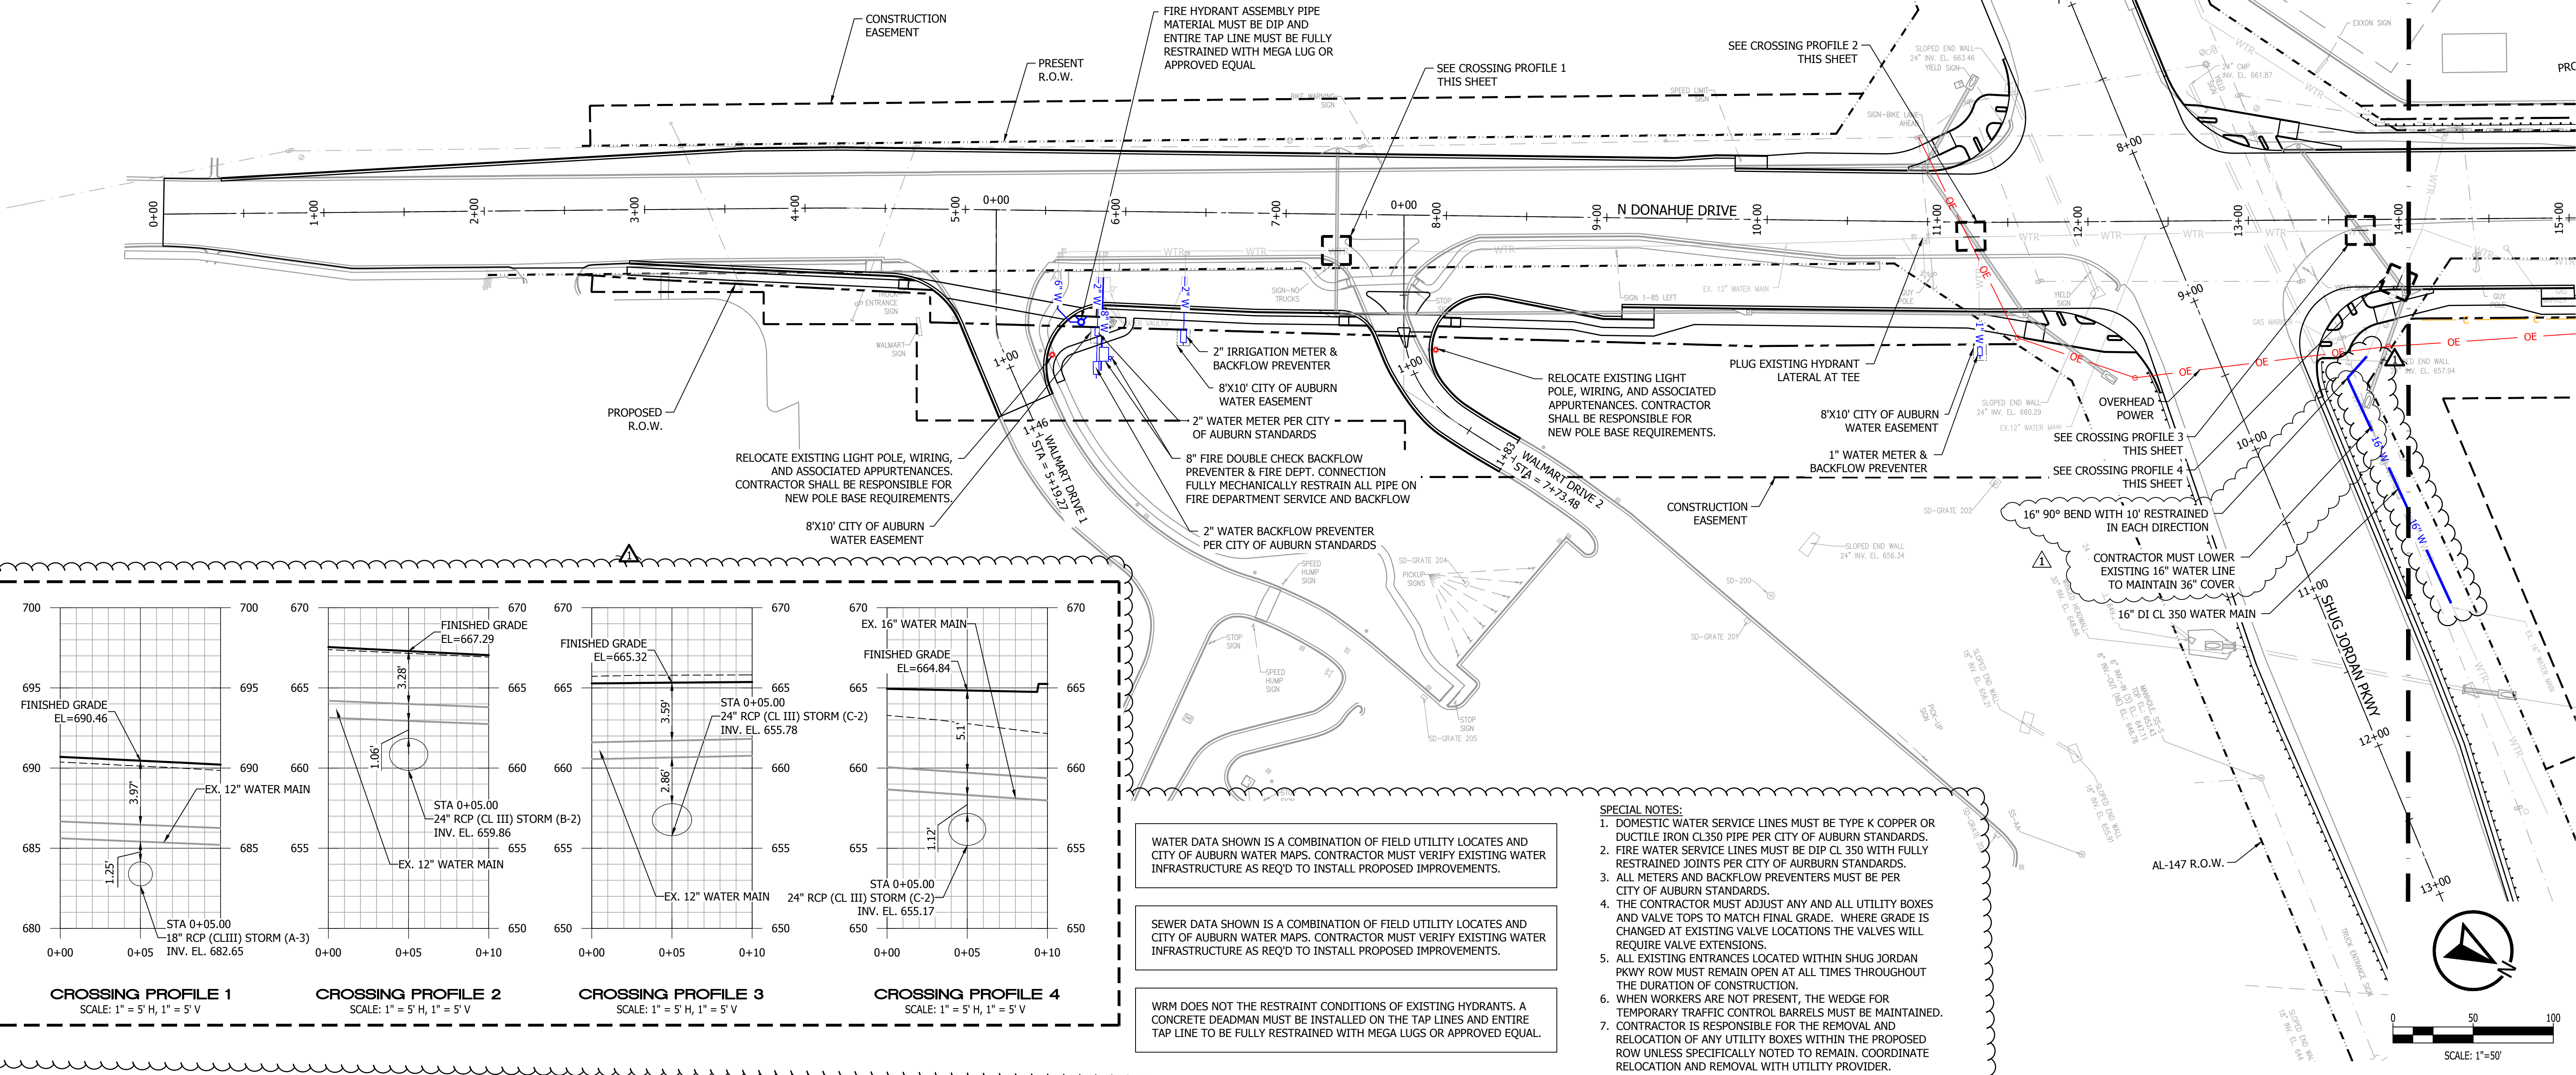

KADRE ENGINEERING
PROJECT NO. 2447 ALTON ROAD, STE 101
24052 BIRMINGHAM, AL 35210
CONTACT: Lee Tharp
AUBURN, ALABAMA 36830
Tel + 334.315.0239
Fax + 334.315.0239
These drawings and design intent are the sole property of KADRE, LLC. which may not be reproduced without written permission


ENGINEERING SERVICES
177 N. ROSS STREET, SUITE 200
AUBURN, ALABAMA 36830
PHONE: (334) 501-3000; FAX: (334) 501-7294




UTILITY PLAN - N. DONAHUE DRIVE
STA 0+00 - 14+00

CITY OF AUBURN
NORTH DONAHUE DRIVE WIDENING

NO.	CHECK	DATE	REVISIONS	
			DESCRIPTION	ADDENDUM #2
1		9/18/2026		
DRAWN			WCW	
CHECKED			BLH	
DATE			09/18/2026	
SCALE			1" = 50'	
SHEET NO.			C6.0	

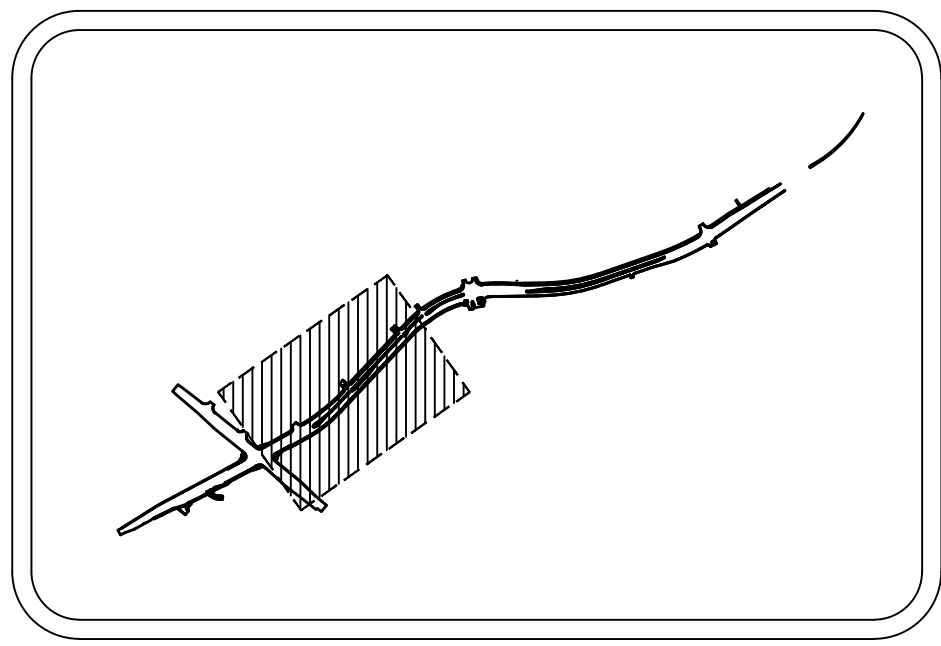

SITE KEY MAP
N.T.S.

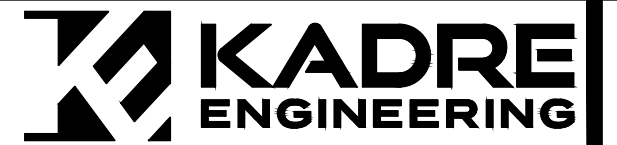

PROJECT NO. 2447 ALTON ROAD, STE 101
24052 BIRMINGHAM, AL 35210
CONTACT: Lee Tharp
Tel + 334.315.0239
Fax + 334.315.0239

These drawings and design intent are the sole property of KADRE, LLC. which may not be reproduced without written permission

ENGINEERING SERVICES
177 N. ROSS STREET, SUITE 200
AUBURN, ALABAMA 36830
PHONE: (334) 501-3000; FAX: (334) 501-7294




UTILITY PLAN - N. DONAHUE DRIVE
STA 14+00 - 28+00

CITY OF AUBURN
NORTH DONAHUE DRIVE WIDENING

NO.	CHECK	DATE	REVISIONS	
			DESCRIPTION	ADDENDUM #2
1		9/18/2026		

DRAWN	WCW
CHECKED	BLH
DATE	09/18/2026
SCALE	1" = 50'
SHEET NO.	C6.1

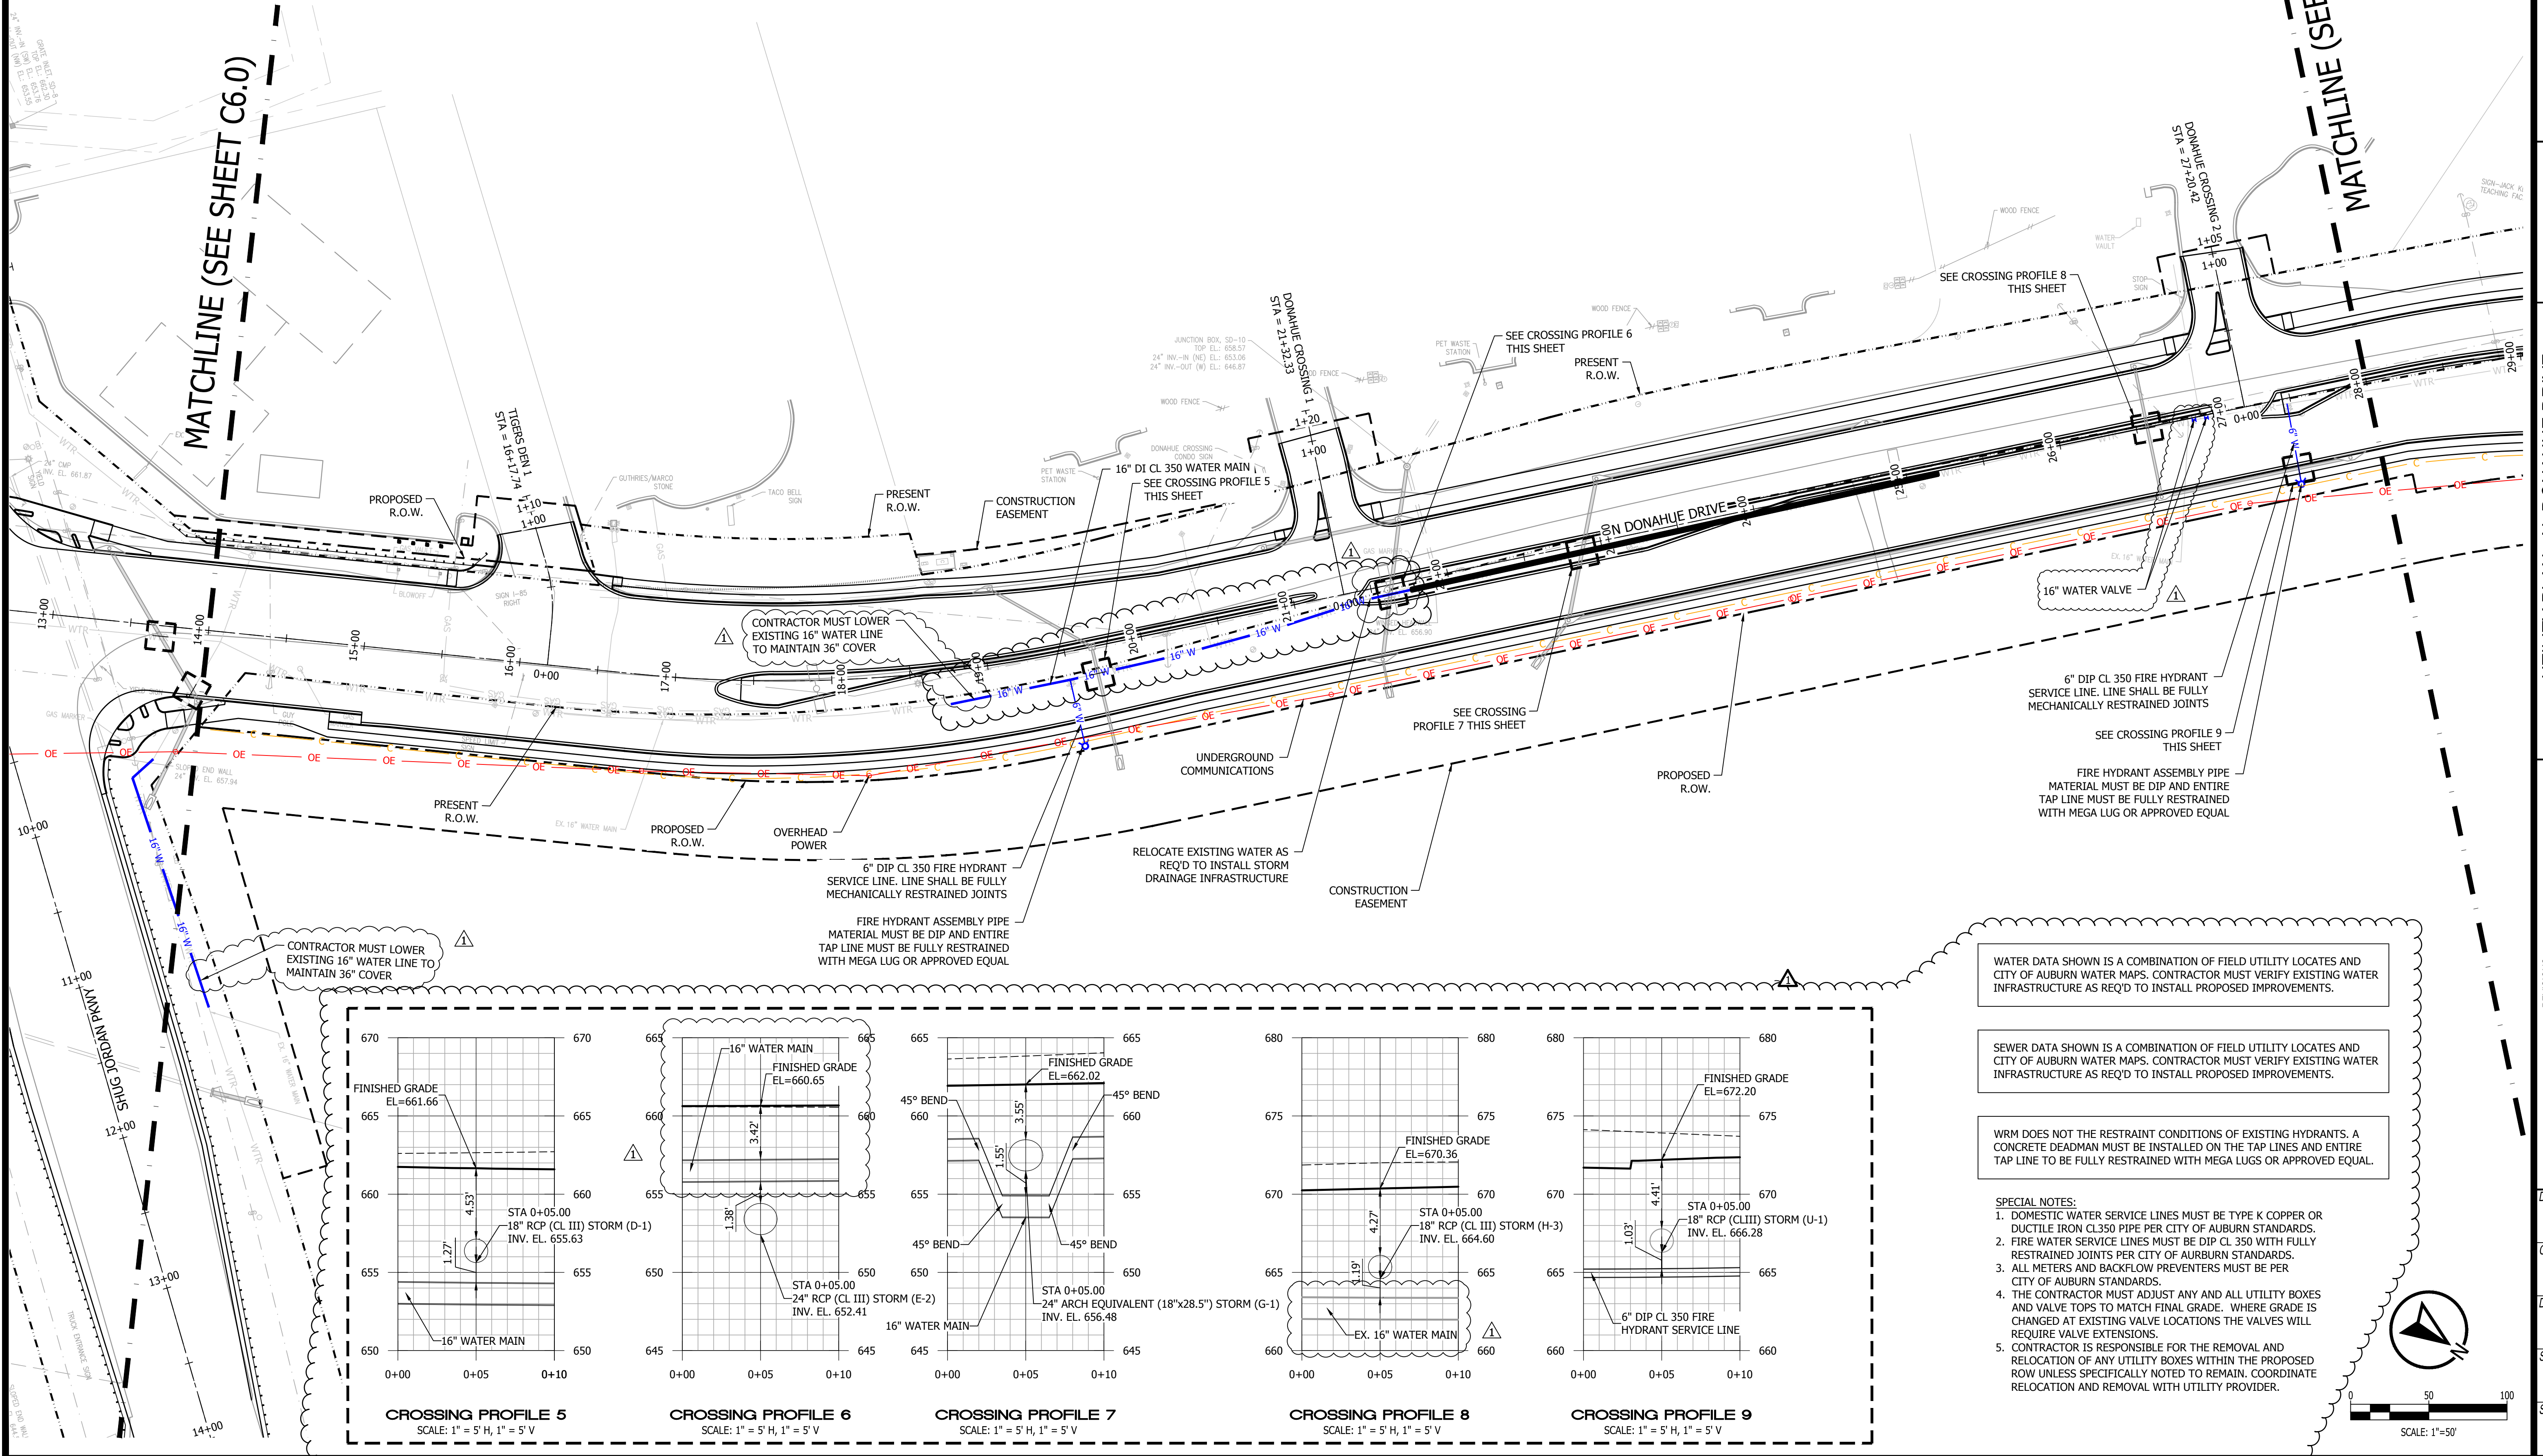

UTILITY PLAN - N. DONAHUE DRIVE


STA 28+00 - 38+00


CITY OF AUBURN

NORTH DONAHUE DRIVE WIDENING

NO.	CHECK	DATE	REVISIONS	
			DESCRIPTION	ADDENDUM #2
1		9/18/2026		

DRAWN	WCW
CHECKED	BLH
DATE	09/18/2026
SCALE	1" = 50'
SHEET NO.	C6.2

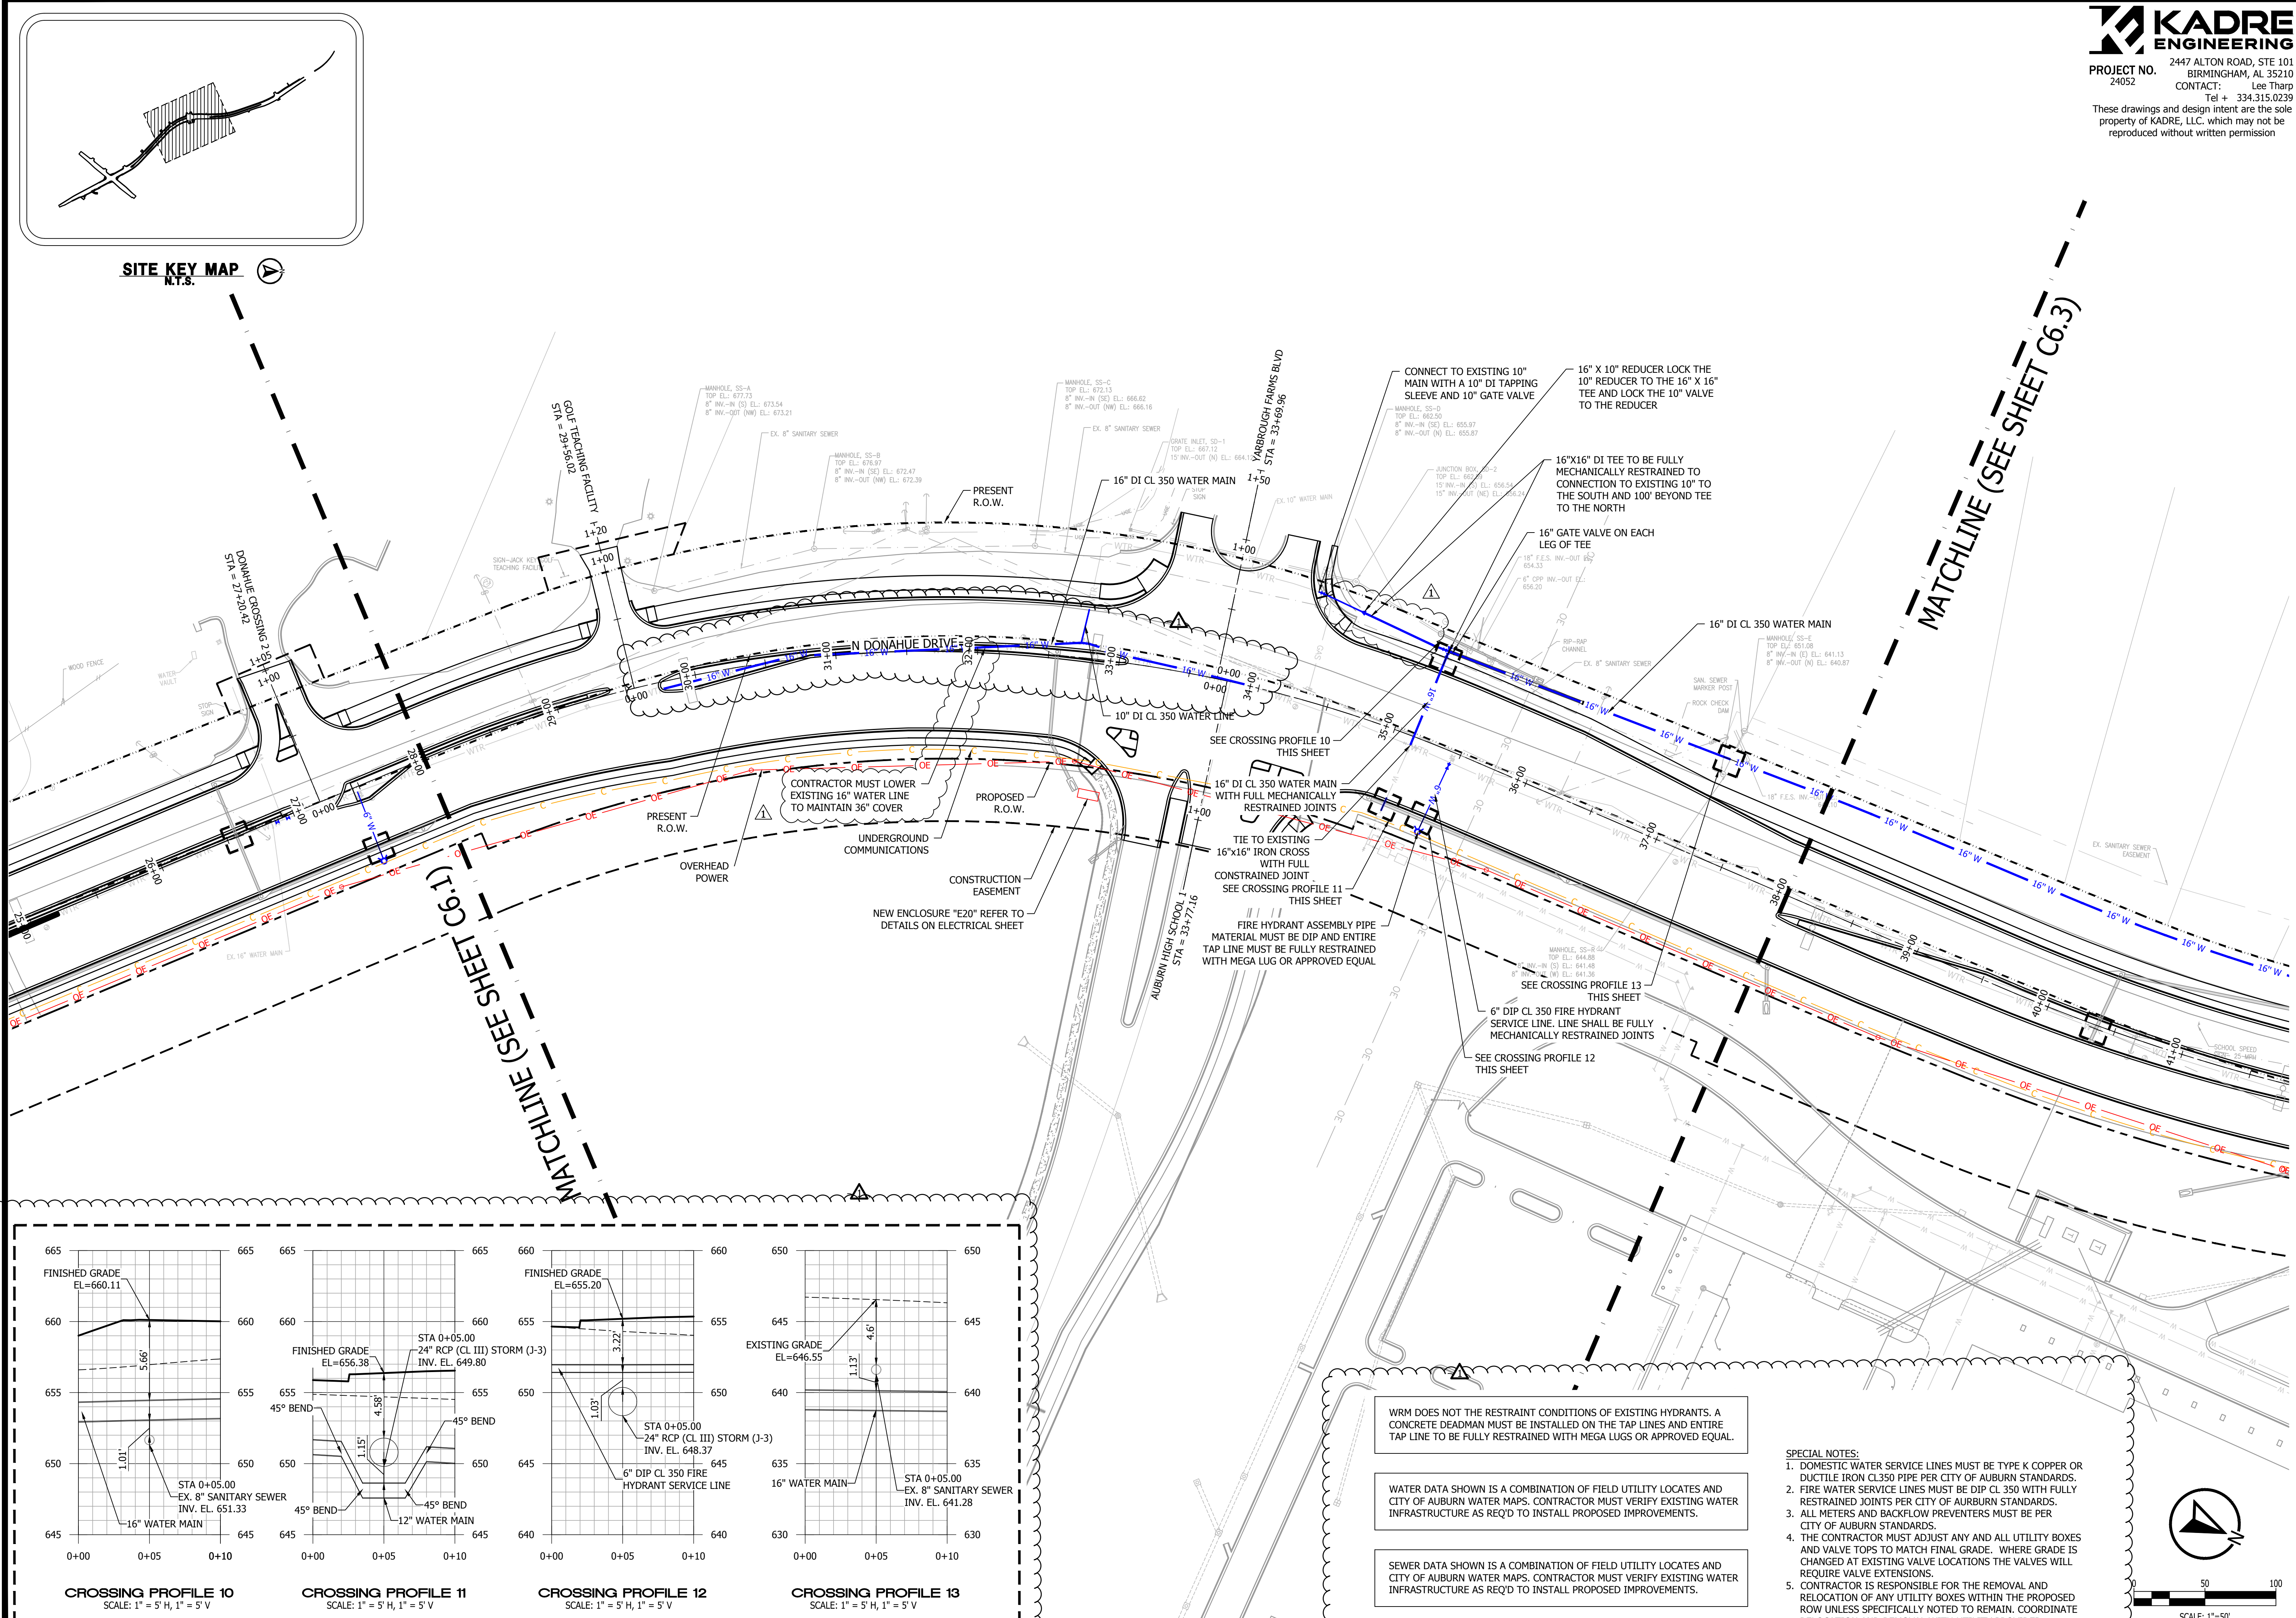

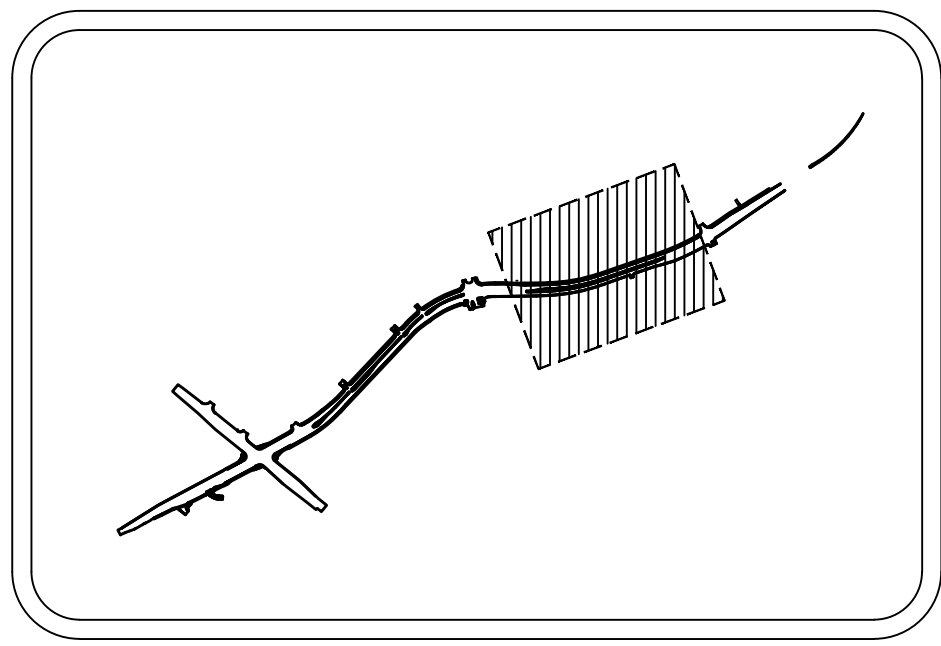

SITE KEY MAP
N.T.S.



PROJECT NO. 2447 ALTON ROAD, STE 101
24052 BIRMINGHAM, AL 35210
CONTACT: Lee Tharp
Tel + 334.315.0239

These drawings and design intent are the sole property of KADRE, LLC. which may not be reproduced without written permission

ENGINEERING SERVICES
177 N. ROSS STREET, SUITE 200
AUBURN, ALABAMA 36830
PHONE: (334) 501-3000; FAX: (334) 501-7294




UTILITY PLAN - N. DONAHUE DRIVE

STA 38+00 - 50+00

CITY OF AUBURN
NORTH DONAHUE DRIVE WIDENING

REVISIONS				DESCRIPTION
NO.	CHECK	DATE	BY	ADDENDUM #2
1		9/18/2026		

DRAWN	WCW
CHECKED	BLH
DATE	09/18/2026
SCALE	1" = 50'
SHEET NO.	C6.3

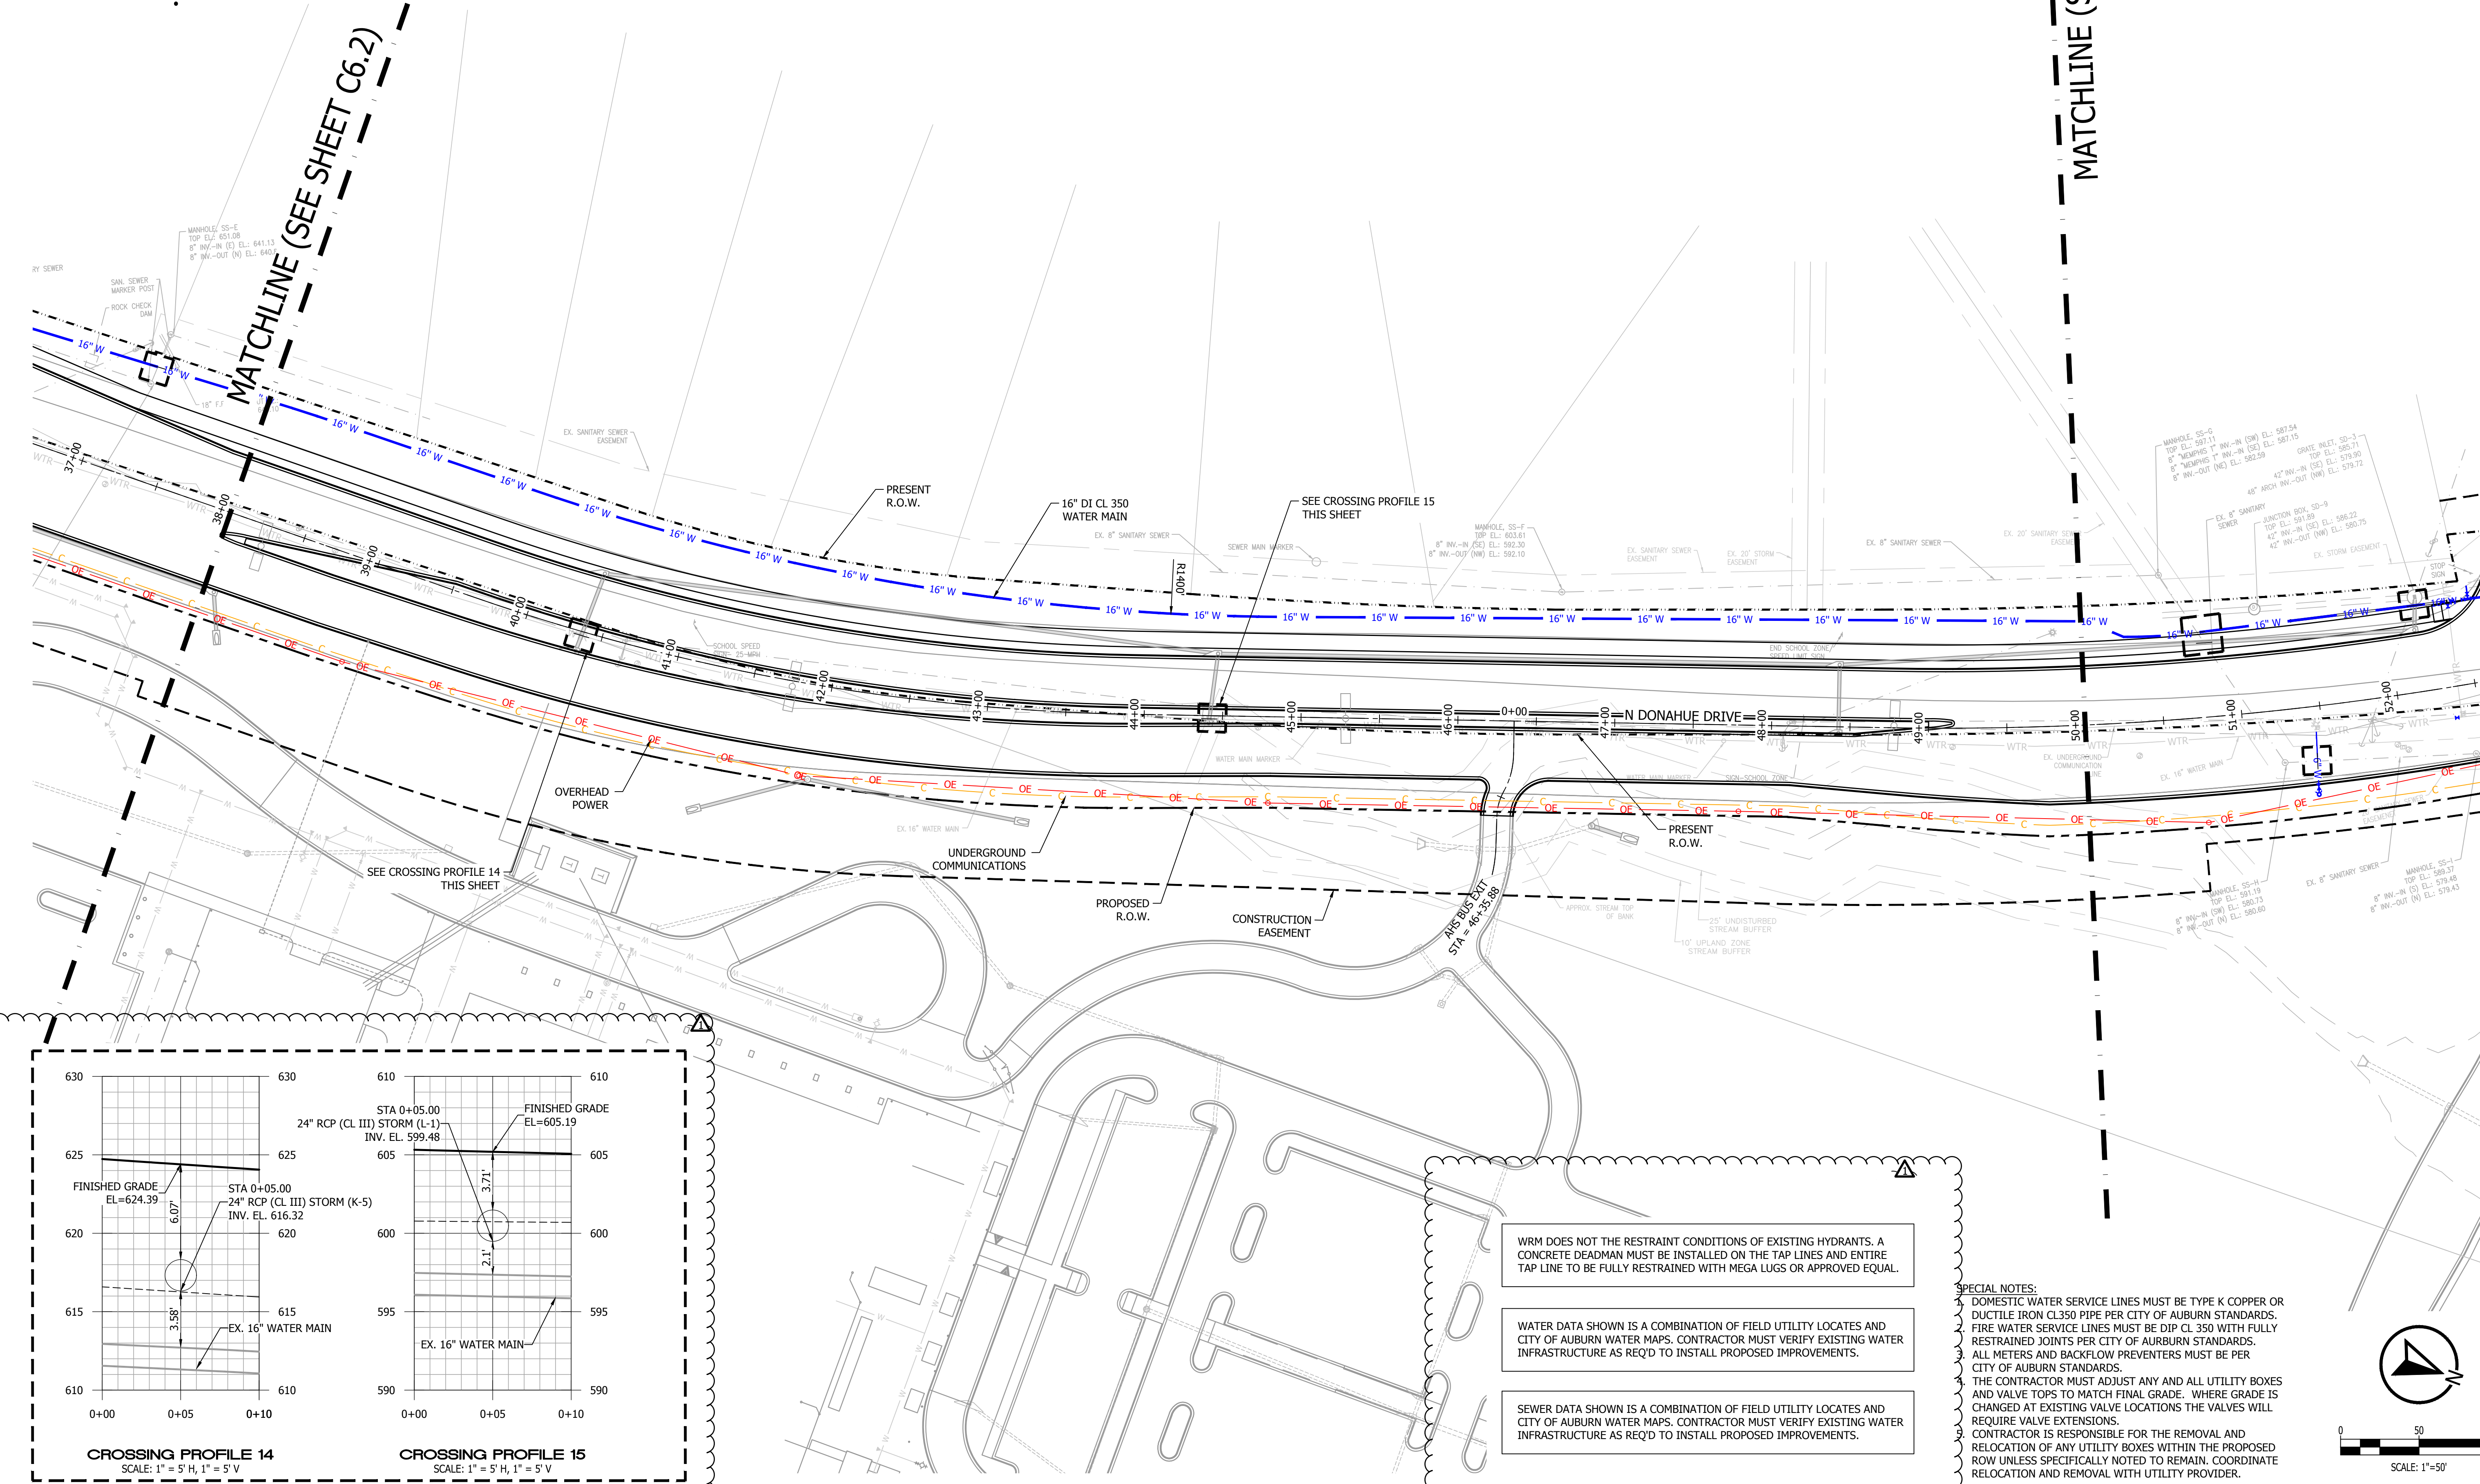



WRM DOES NOT THE RESTRAINT CONDITIONS OF EXISTING HYDRANTS. A CONCRETE DEADMAN MUST BE INSTALLED ON THE TAP LINES AND ENTIRE TAP LINE TO BE FULLY RESTRAINED WITH MEGA LUGS OR APPROVED EQUAL.

WATER DATA SHOWN IS A COMBINATION OF FIELD UTILITY LOCATES AND CITY OF AUBURN WATER MAPS. CONTRACTOR MUST VERIFY EXISTING WATER INFRASTRUCTURE AS REQ'D TO INSTALL PROPOSED IMPROVEMENTS.

SEWER DATA SHOWN IS A COMBINATION OF FIELD UTILITY LOCATES AND CITY OF AUBURN WATER MAPS. CONTRACTOR MUST VERIFY EXISTING WATER INFRASTRUCTURE AS REQ'D TO INSTALL PROPOSED IMPROVEMENTS.


SPECIAL NOTES:
1. DOMESTIC WATER SERVICE LINES MUST BE TYPE K COPPER OR DUCTILE IRON CL350 PIPE PER CITY OF AUBURN STANDARDS.
2. FIRE WATER SERVICE LINES MUST BE DIP CL 350 WITH FULLY RESTRAINED JOINTS PER CITY OF AUBURN STANDARDS.
3. ALL METERS AND BACKFLOW PREVENTERS MUST BE PER CITY OF AUBURN STANDARDS.
4. THE CONTRACTOR MUST ADJUST ANY AND ALL UTILITY BOXES AND VALVE TOPS TO MATCH FINAL GRADE. WHERE GRADE IS CHANGED AT EXISTING VALVE LOCATIONS THE VALVES WILL REQUIRE VALVE EXTENSIONS.
5. CONTRACTOR IS RESPONSIBLE FOR THE REMOVAL AND RELOCATION OF ANY UTILITY BOXES WITHIN THE PROPOSED ROW UNLESS SPECIFICALLY NOTED TO REMAIN. COORDINATE RELOCATION AND REMOVAL WITH UTILITY PROVIDER.

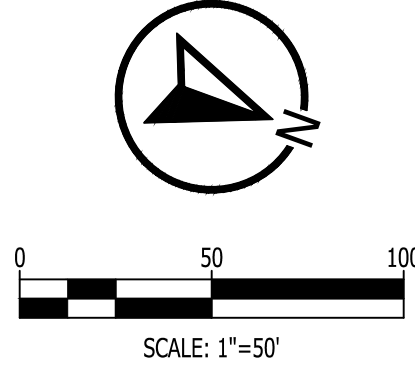

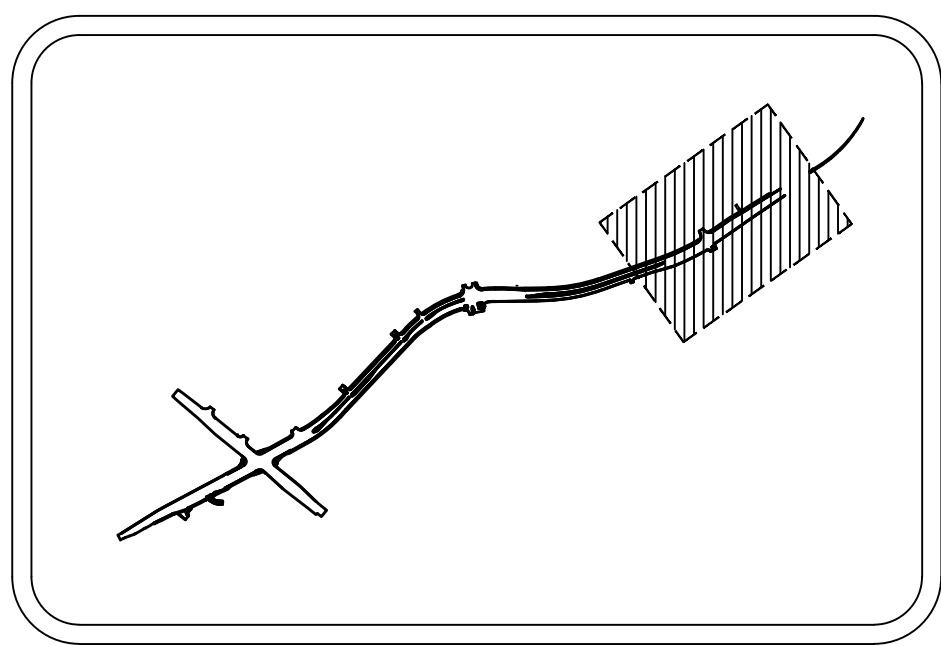

SITE KEY MAP
N.T.S.

MATCHLINE (SEE SHEET C6.3)

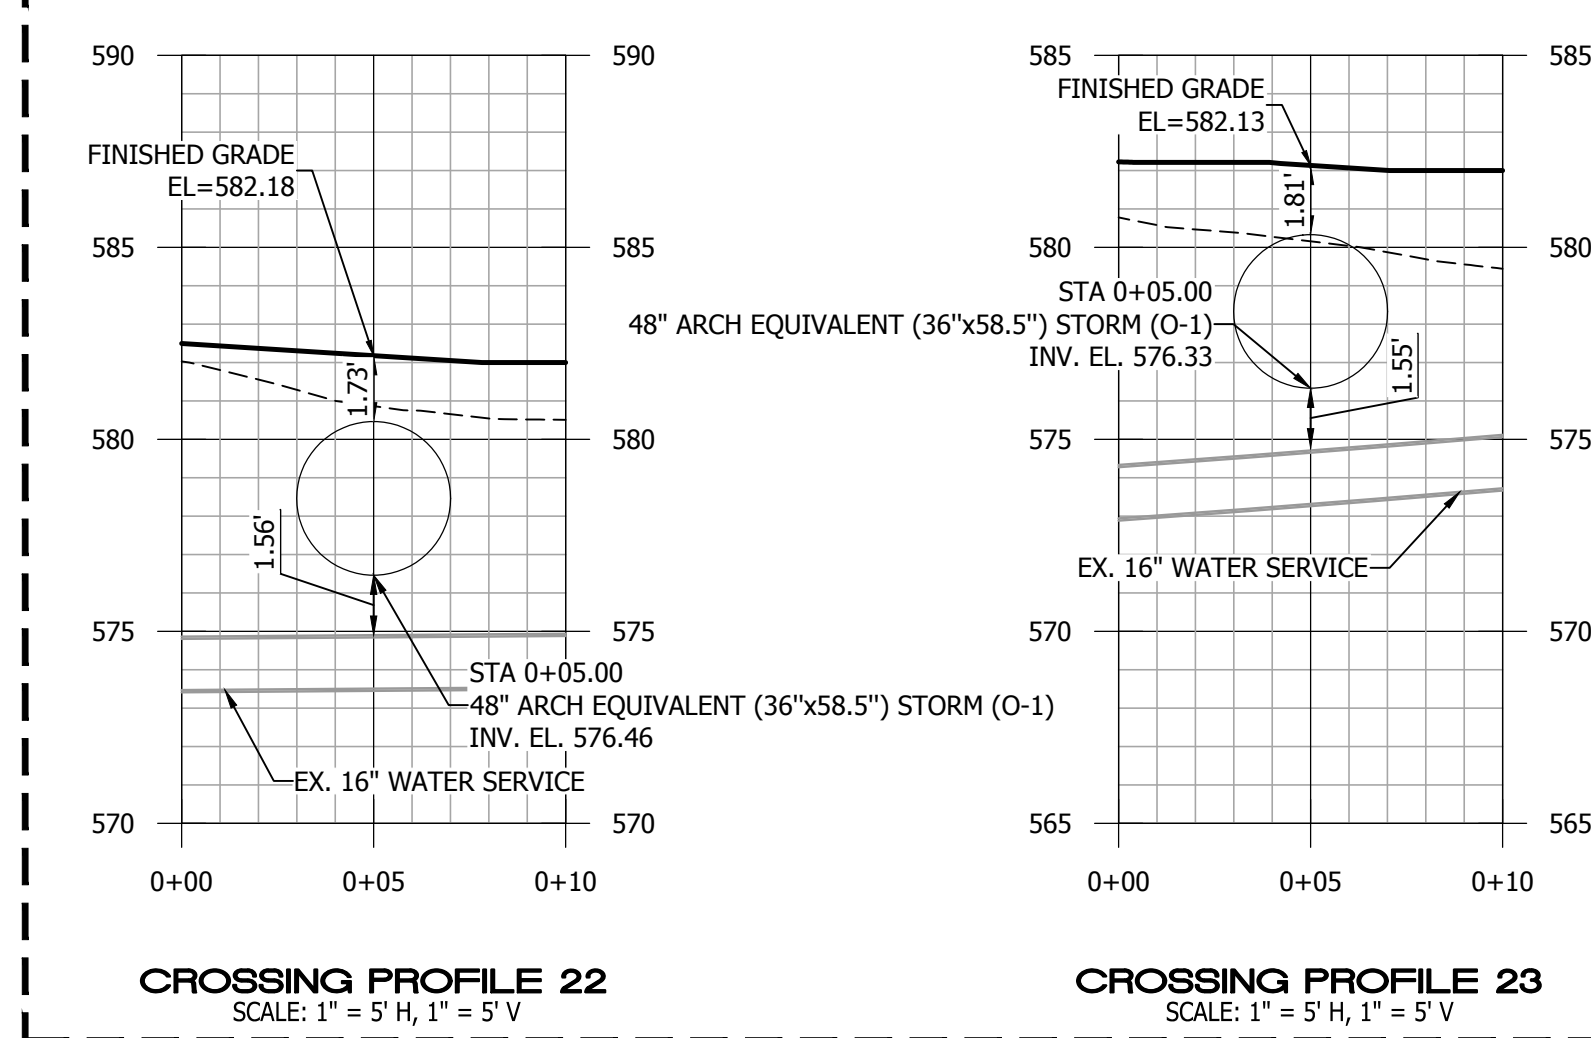

- SPECIAL NOTES:
1. DOMESTIC WATER SERVICE LINES MUST BE TYPE K COPPER OR DUCTILE IRON CL350 PIPE PER CITY OF AUBURN STANDARDS.
 2. FIRE WATER SERVICE LINES MUST BE DIP CL 350 WITH FULLY RESTRAINED JOINTS PER CITY OF AUBURN STANDARDS.
 3. ALL METERS AND BACKFLOW PREVENTERS MUST BE PER CITY OF AUBURN STANDARDS.
 4. THE CONTRACTOR MUST ADJUST ANY AND ALL UTILITY BOXES AND VALVE TOPS TO MATCH FINAL GRADE. WHERE GRADE IS CHANGED AT EXISTING VALVE LOCATIONS THE VALVES WILL REQUIRE VALVE EXTENSIONS.
 5. CONTRACTOR IS RESPONSIBLE FOR THE REMOVAL AND RELOCATION OF ANY UTILITY BOXES WITHIN THE PROPOSED ROW UNLESS SPECIFICALLY NOTED TO REMAIN. COORDINATE RELOCATION AND REMOVAL WITH UTILITY PROVIDER.

WRM DOES NOT THE RESTRAINT CONDITIONS OF EXISTING HYDRANTS. A CONCRETE DEADMAN MUST BE INSTALLED ON THE TAP LINES AND ENTIRE TAP LINE TO BE FULLY RESTRAINED WITH MEGA LUGS OR APPROVED EQUAL.

WATER DATA SHOWN IS A COMBINATION OF FIELD UTILITY LOCATES AND CITY OF AUBURN WATER MAPS. CONTRACTOR MUST VERIFY EXISTING WATER INFRASTRUCTURE AS REQ'D TO INSTALL PROPOSED IMPROVEMENTS.

SEWER DATA SHOWN IS A COMBINATION OF FIELD UTILITY LOCATES AND CITY OF AUBURN WATER MAPS. CONTRACTOR MUST VERIFY EXISTING WATER INFRASTRUCTURE AS REQ'D TO INSTALL PROPOSED IMPROVEMENTS.

MATCHLINE (SEE SHEET C6.5)

KADRE ENGINEERING
PROJECT NO. 2447 ALTON ROAD, STE 101
24052 BIRMINGHAM, AL 35210
CONTACT: Lee Tharp
Tel + 334.315.0239
These drawings and design intent are the sole property of KADRE, LLC. which may not be reproduced without written permission

ENGINEERING SERVICES
177 N. ROSS STREET, SUITE 200
AUBURN, ALABAMA 36830
PHONE: (334) 501-3000; FAX: (334) 501-7294






UTILITY PLAN - N. DONAHUE DRIVE


STA 50+00 - 60+00

CITY OF AUBURN

NORTH DONAHUE DRIVE WIDENING

REVISIONS		DESCRIPTION	ADDENDUM #2
NO.	CHECK	DATE	
1		9/18/2026	
DRAWN		WCW	
CHECKED		BLH	
DATE		09/18/2026	
SCALE		1" = 50'	
SHEET NO.		C6.4	

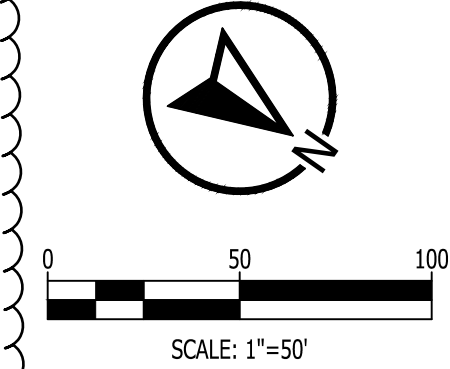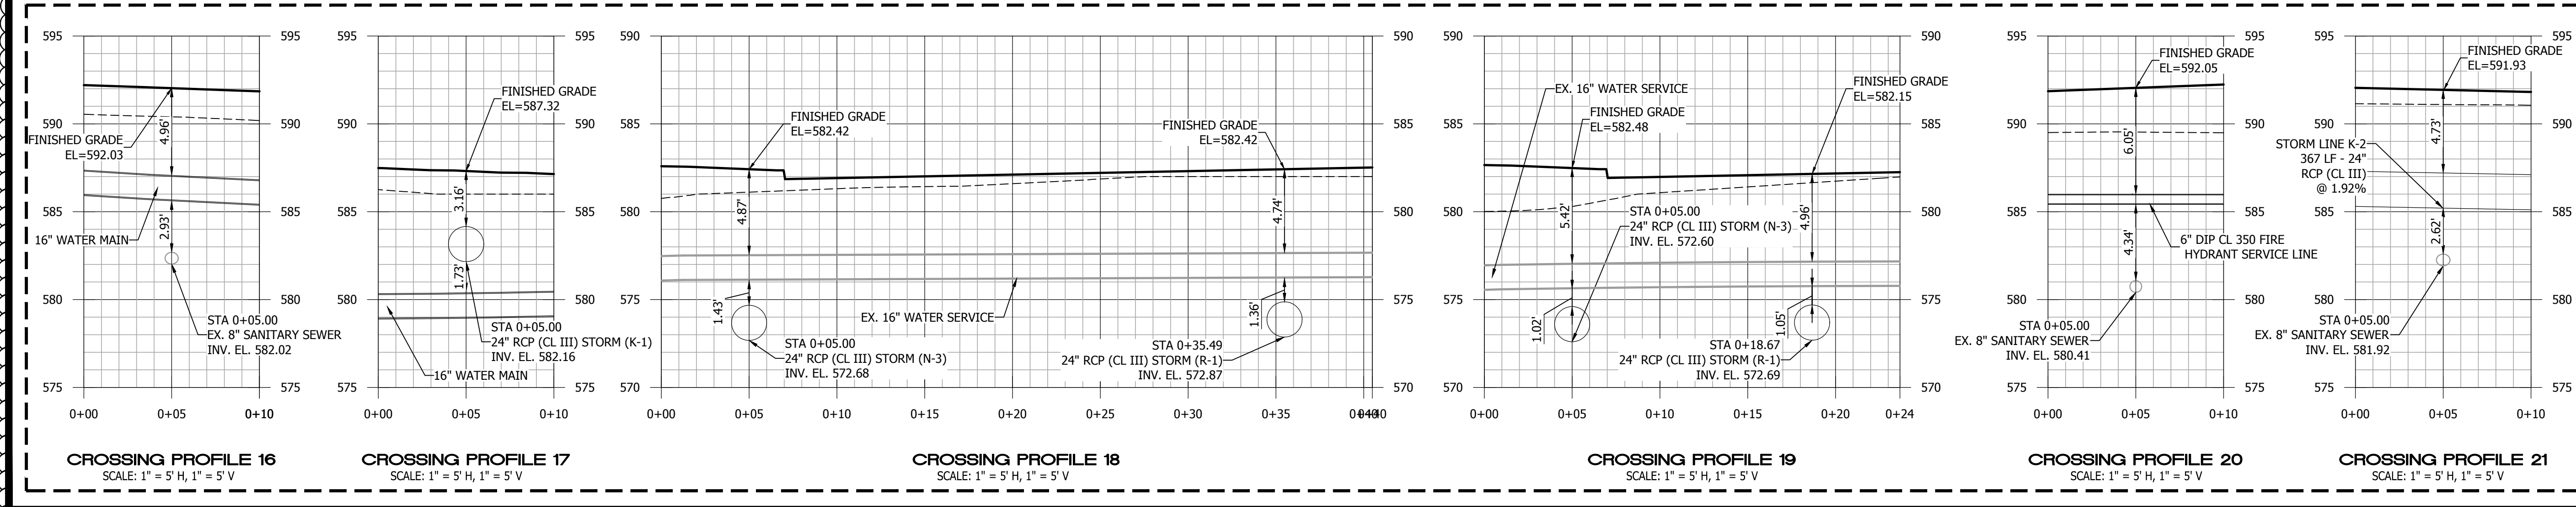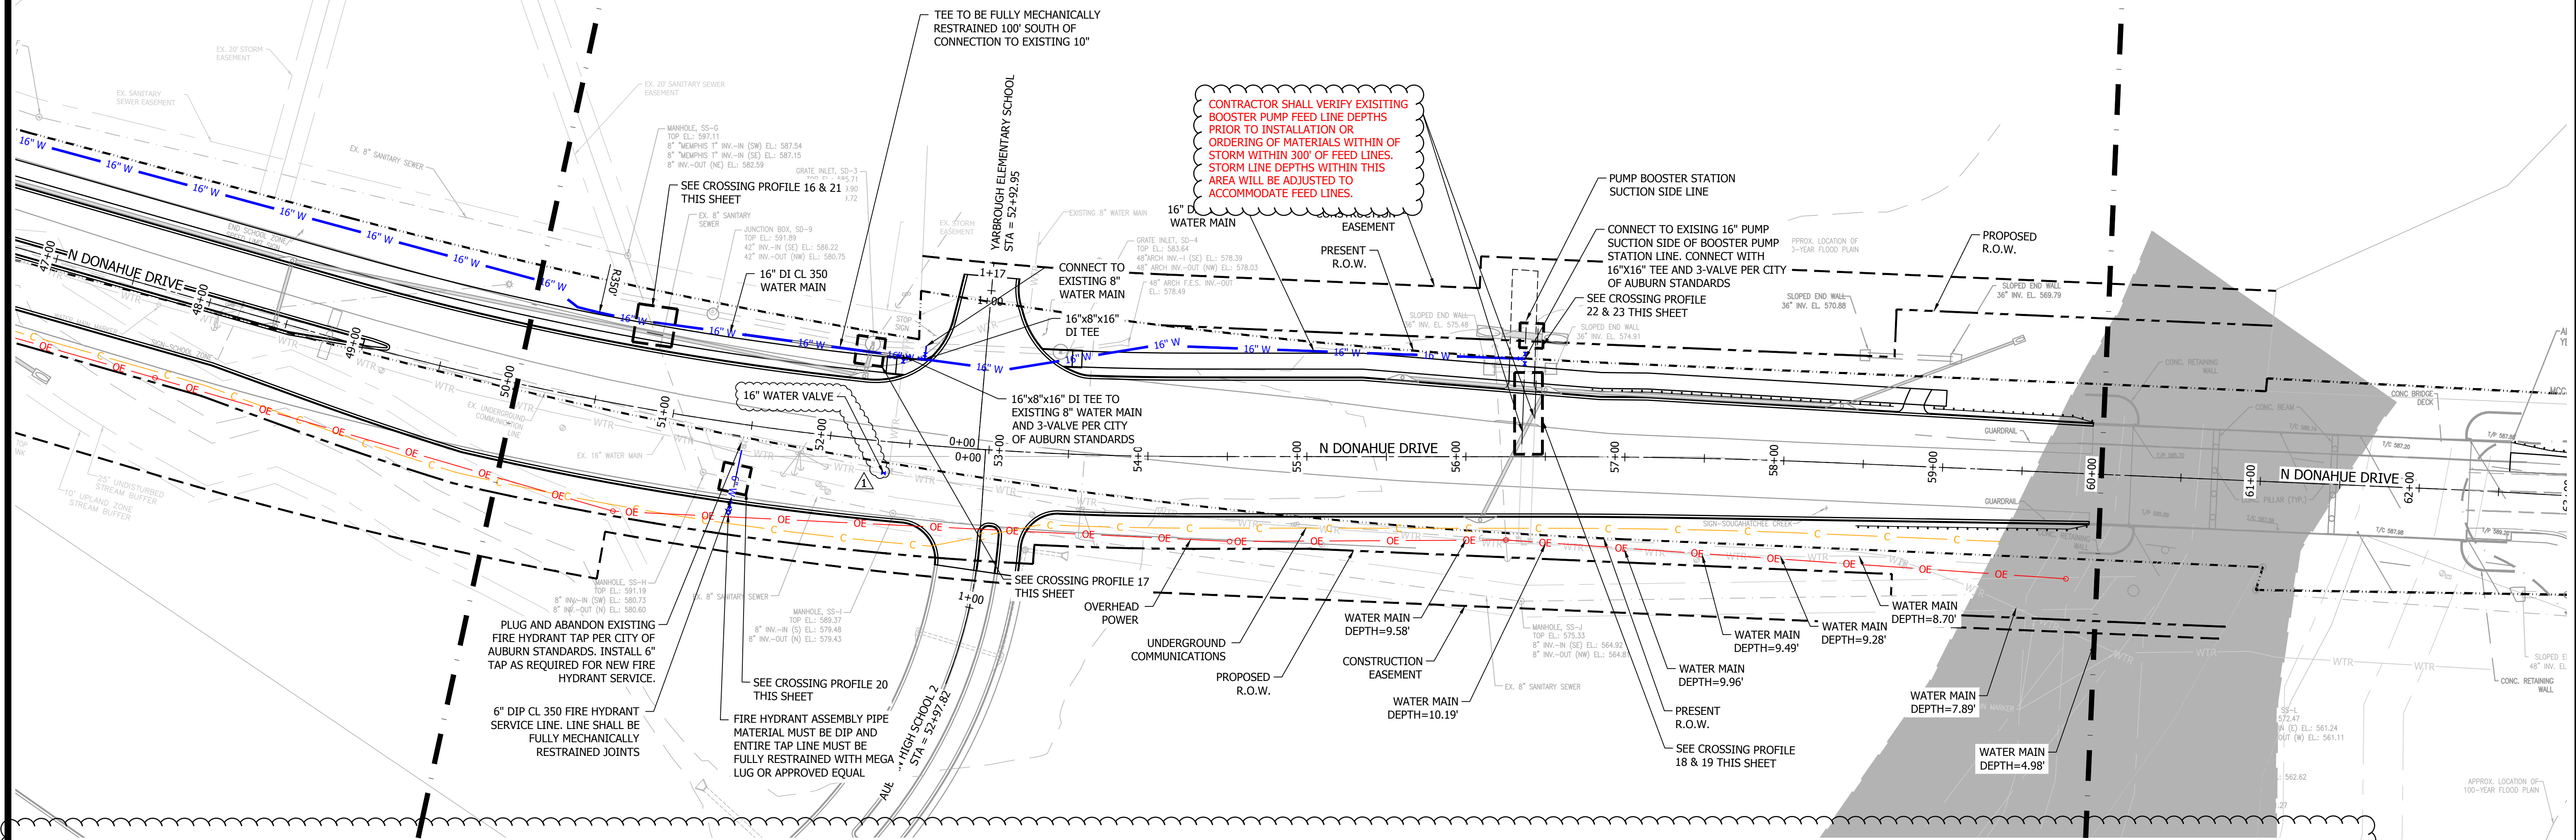

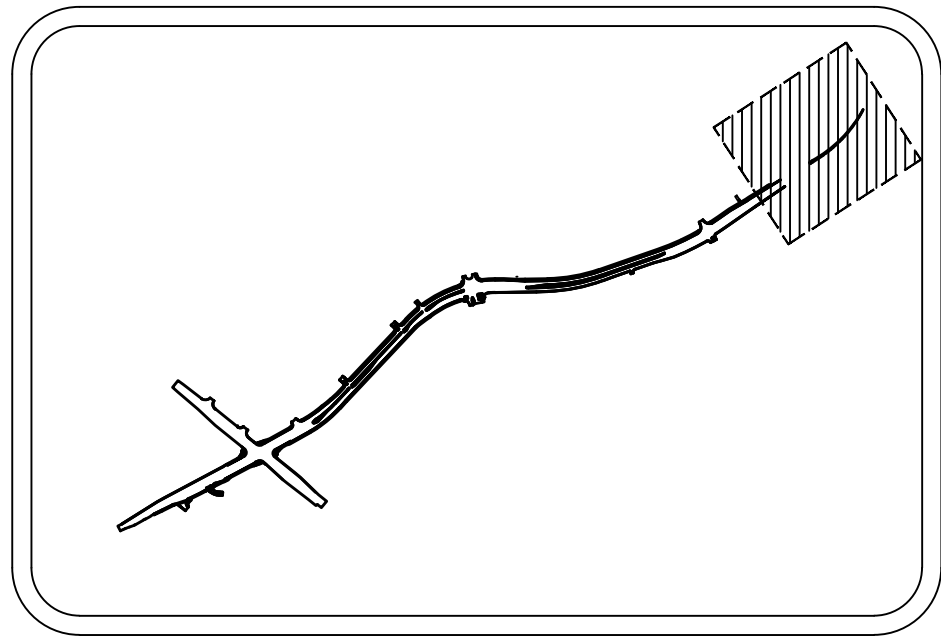

SITE KEY MAP
N.T.S.




PROJECT NO. 2447 ALTON ROAD, STE 101
24052 BIRMINGHAM, AL 35210
CONTACT: Lee Tharp
Tel + 334.315.0239
These drawings and design intent are the sole property of KADRE, LLC. which may not be reproduced without written permission

ENGINEERING SERVICES
177 N. ROSS STREET, SUITE 200
AUBURN, ALABAMA 36830
PHONE: (334) 501-3000; FAX: (334) 501-7294



UTILITY PLAN - N. DONAHUE DRIVE
STA 60+00 - 69+00

CITY OF AUBURN
NORTH DONAHUE DRIVE WIDENING

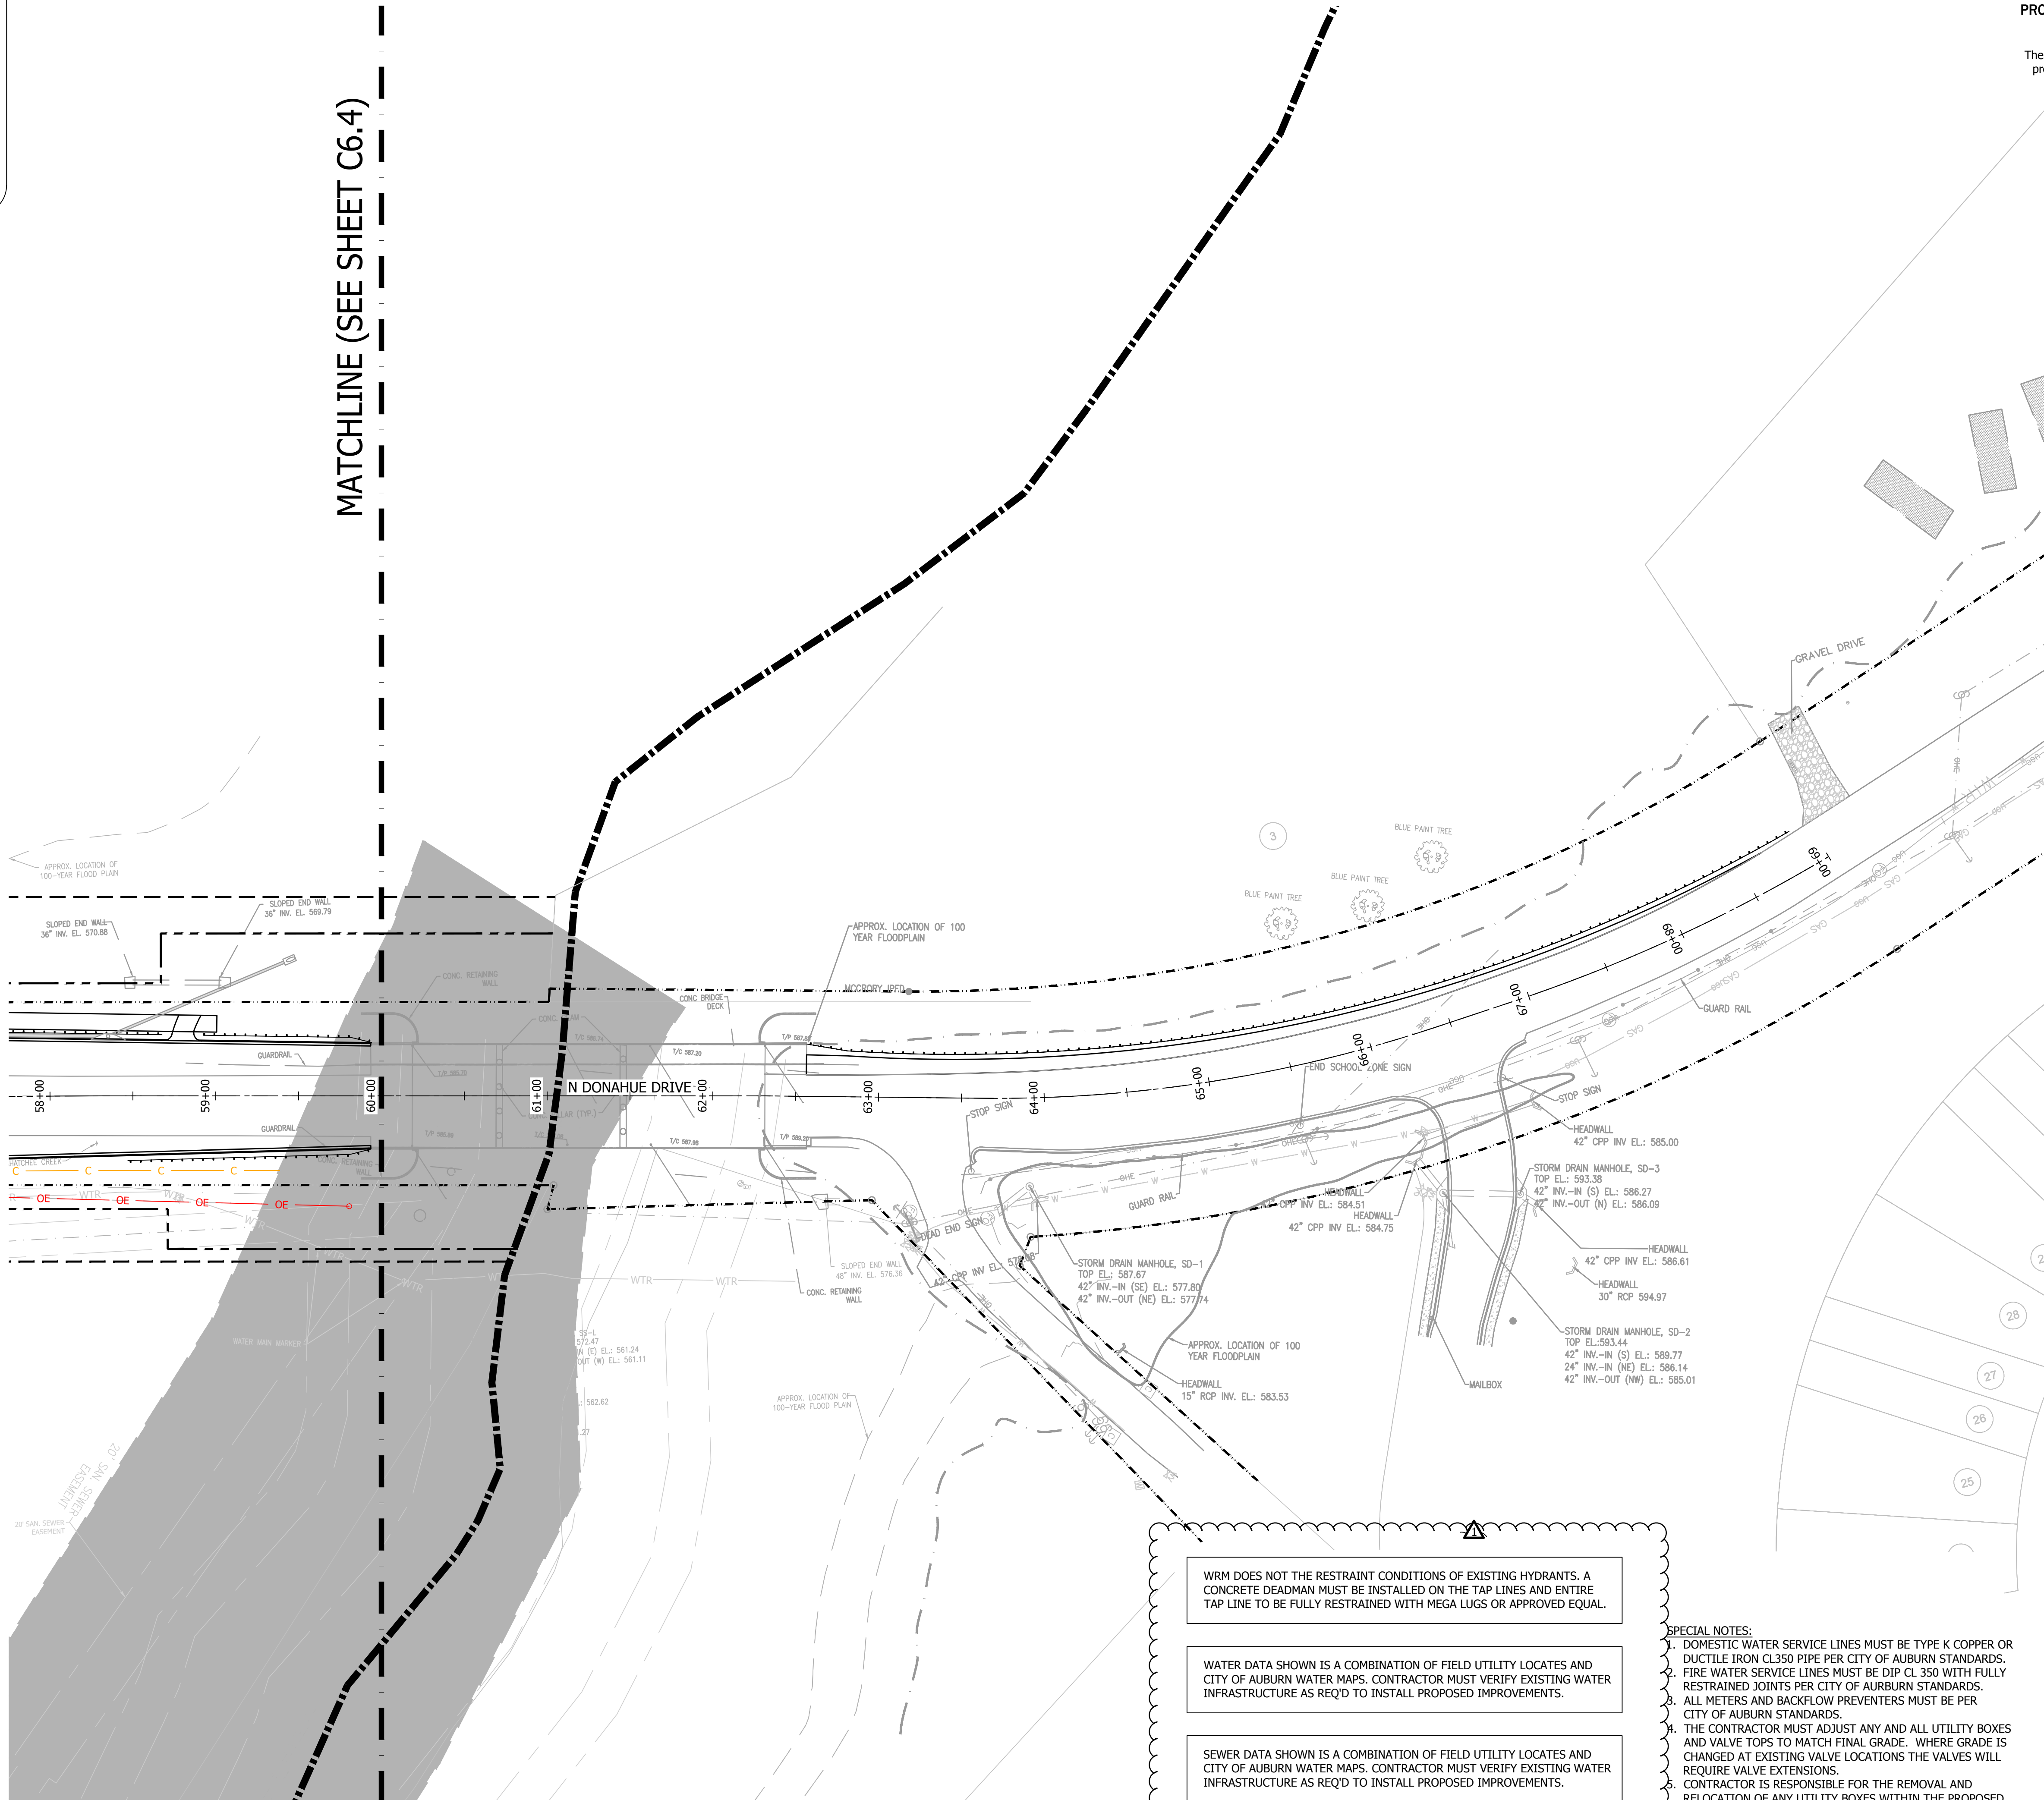


WRM DOES NOT THE RESTRAINT CONDITIONS OF EXISTING HYDRANTS. A CONCRETE DEADMAN MUST BE INSTALLED ON THE TAP LINES AND ENTIRE TAP LINE TO BE FULLY RESTRAINED WITH MEGA LUGS OR APPROVED EQUAL.

WATER DATA SHOWN IS A COMBINATION OF FIELD UTILITY LOCATES AND CITY OF AUBURN WATER MAPS. CONTRACTOR MUST VERIFY EXISTING WATER INFRASTRUCTURE AS REQ'D TO INSTALL PROPOSED IMPROVEMENTS.

SEWER DATA SHOWN IS A COMBINATION OF FIELD UTILITY LOCATES AND CITY OF AUBURN WATER MAPS. CONTRACTOR MUST VERIFY EXISTING WATER INFRASTRUCTURE AS REQ'D TO INSTALL PROPOSED IMPROVEMENTS.

- SPECIAL NOTES:
1. DOMESTIC WATER SERVICE LINES MUST BE TYPE K COPPER OR DUCTILE IRON CL 350 PIPE PER CITY OF AUBURN STANDARDS.
 2. FIRE WATER SERVICE LINES MUST BE DIP CL 350 WITH FULLY RESTRAINED JOINTS PER CITY OF AUBURN STANDARDS.
 3. ALL METERS AND BACKFLOW PREVENTERS MUST BE PER CITY OF AUBURN STANDARDS.
 4. THE CONTRACTOR MUST ADJUST ANY AND ALL UTILITY BOXES AND VALVE TOPS TO MATCH FINAL GRADE. WHERE GRADE IS CHANGED AT EXISTING VALVE LOCATIONS THE VALVES WILL REQUIRE VALVE EXTENSIONS.
 5. CONTRACTOR IS RESPONSIBLE FOR THE REMOVAL AND RELOCATION OF ANY UTILITY BOXES WITHIN THE PROPOSED ROW UNLESS SPECIFICALLY NOTED TO REMAIN. COORDINATE RELOCATION AND REMOVAL WITH UTILITY PROVIDER.

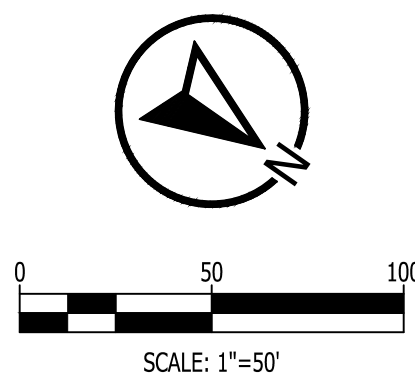

REVISIONS			
NO.	CHECK	DATE	DESCRIPTION ADDENDUM #2
1		9/18/2026	

DRAWN WCW	
CHECKED BLH	
DATE 09/18/2026	
SCALE 1" = 50'	
SHEET NO. C6.5	

NORTH DONAHUE DRIVE WIDENING PHASE 1**BASE BID***Revised September 18, 2026***SCHEDULE OF ESTIMATED QUANTITIES AND BID PRICES**

ITEM #	DESCRIPTION	UNIT	QUANTITY	UNIT COST	TOTAL COST
201A002	CLEARING & GRUBBING (MAXIMUM ALLOWABLE BID \$4,000 PER ACRE)	ACRE	12		
206C000	REMOVE CONCRETE SIDEWALK	SQ YD	353		
206C001	REMOVE CONCRETE PAVEMENT	SQ YD	510		
206D000	REMOVING PIPE	LN FT	498		
206D001	REMOVING GUARDRAIL	LN FT	240		
206D003	REMOVING CURB AND GUTTER	LN FT	3,111		
206E000	REMOVING HEADWALLS	EACH	13		
206E008	REMOVING GUARDRAIL END ANCHOR (ALL TYPES)	EACH	6		
210A000	UNCLASSIFIED EXCAVATION	CB YD	23,500		
210D021	BORROW EXCAVATION (LOOSE TRUCKBED MEASUREMENT) (A4 OR BETTER)	CB YD	23,000		
230B000	ROADBED PROCESSING	SQ YD	7,000		
301B008	CRUSHED AGGREGATE BASE COURSE, TYPE B, PLANT MIXED	CB YD	11,340		
327A020	PLANT MIX BITUMINOUS BASE, MIX 1	TON	642		
405A000	TACK COAT	GALLON	4290		
408A051	PLANING EXISTING PAVEMENT (APPROXIMATELY 0.00" THRU 1.0" THICK)	SQ YD	20,155		
424A356	SUPERPAVE BITUMINOUS CONCRETE WEARING SURFACE LAYER, 3/8" MAX. AGG. SIZE MIX, ESAL RANGE C/D (1.5" THICK)	TON	2,400		
424B650	SUPERPAVE BITUMINOUS CONCRETE UPPER BINDER LAYER, 3/4" MAX. AGG. SIZE MIX, ESAL RANGE C/D (2.25" THICK)	TON	5,310		
424B681	SUPERPAVE BITUMINOUS CONCRETE LOWER BINDER LAYER, 1" MAX. AGG. SIZE MIX, ESAL RANGE C/D (2.75" THICK)	TON	6,475		
450A016	REINFORCED CEMENT CONCRETE PAVEMENT, 12 INCHES THICK	SQ YD	328		
530A000	15" ROADWAY PIPE (CLASS 3 R.C.)	LN FT	79		
530A001	18" ROADWAY PIPE (CLASS 3 R.C.)	LN FT	1,339		
530A002	24" ROADWAY PIPE (CLASS 3 R.C.)	LN FT	3,281		
530A003	30" ROADWAY PIPE (CLASS 3 R.C.)	LN FT	288		
530A006	48" ROADWAY PIPE (CLASS 3 R.C.)	LN FT	57		
530A033	12" ROADWAY PIPE (CLASS 3 R.C.)	LN FT	25		
600A000	MOBILIZATION	LS	1		
610C000	LOOSE RIPRAP, CLASS 1	TON	120		

610D003	FILTER BLANKET, GEOTEXTILE	SQ YD	200		
614A000	SLOPE PAVING	CB YD	10		
618A000	CONCRETE SIDEWALK, 4" THICK	SQ YD	6,892		
618A001	CONCRETE DRIVEWAY, 6" THICK	SQ YD	180		
618C001	DETECTABLE WARNING SURFACE	SQ FT	37		
618D000	CURB RAMP	SQ YD	384		
621C015	INLETS, TYPE S1 OR S3 (1 WING)	EACH	29		
621C017	INLETS, TYPE S1 OR S3 (2 WING)	EACH	4		
622A002	MANHOLE COVERS RESET (SANITARY)	EACH	6		
623B000	CONCRETE CURB, TYPE N	LN FT	1,684		
623B001	CONCRETE CURB, TYPE N SPECIAL	LN FT	379		
623C003	COMBINATION CURB AND GUTTER, TYPE C (MODIFIED)	LN FT	17,430		
630A001	STEEL BEAM GUARDRAIL, CLASS A, TYPE 2	LN FT	2,086		
630C077	GUARDRAIL END ANCHOR, TYPE 8 (MASH)	EACH	11		
630C080	GUARDRAIL END ANCHOR, TYPE 20 (MASH)	EACH	3		
640A005	UNDERGROUND UTILITY ADJUSTMENT (16" WATER AND ASSOCIATED APPURTENANCES INCLUDING MAIN LINE VALVES)	LF	895		
641A514	1" COPPER WATER SERVICE LINE LAID	LN FT	23		
641A518	2" COPPER WATER SERVICE LINE LAID	LN FT	106		
641A614	8" DUCTILE IRON WATER MAIN LAID	LN FT	58		
641A616	10" DUCTILE IRON WATER MAIN LAID	LN FT	33		
641A622	16" DUCTILE IRON WATER MAIN LAID	LN FT	1,564		
641A692	16" DUCTILE IRON WATER MAIN LAID (RESTRAINED JOINT)	LN FT	278		
641E500	FIRE HYDRANT RESET	EACH	6		
641Q500	WATER METER AND BOX RESET	EACH	4		
641S500	VALVE BOX RESET	EACH	9		
650B000	TOPSOIL FROM STOCKPILES	CB YD	3,590		
652A100	SEEDING	ACRE	7		
654A001	SOLID SODDING (BERMUDA)	SQ YD	1,000		
656A010	MULCHING	ACRE	7		
665A000	TEMPORARY SEEDING	ACRE	14		
665J002	SILT FENCE	LN FT	17,762		
665P005	INLET PROTECTION, STAGE 3 OR 4	EACH	33		

665Q002	WATTLE	LN FT	1,600		
680A001	GEOMETRIC CONTROLS	LS	1		
698A000	CONSTRUCTION FUEL (MAXIMUM BID LIMITED TO \$357,000)	LS	1		
701A227	SOLID WHITE, CLASS 2, TYPE A TRAFFIC STRIPE (5" WIDE)	MILE	5.6		
701A230	SOLID YELLOW, CLASS 2, TYPE A TRAFFIC STRIPE (5" WIDE)	MILE	3.2		
701A239	BROKEN WHITE, CLASS 2, TYPE A TRAFFIC STRIPE (5" WIDE)	MILE	2.5		
701A244	BROKEN YELLOW, CLASS 2, TYPE A TRAFFIC STRIPE (5" WIDE)	MILE	0.2		
701B207	DOTTED WHITE, CLASS 2, TYPE A TRAFFIC STRIPE (5" WIDE)	LN FT	6,473		
701C000	BROKEN TEMPORARY TRAFFIC STRIPE	MILE	0.11		
701C001	SOLID TEMPORARY TRAFFIC STRIPE	MILE	4.74		
703A002	TRAFFIC CONTROL MARKINGS, CLASS 2, TYPE A	SQ FT	42875		
703B002	TRAFFIC CONTROL LEGENDS, CLASS 2, TYPE A	SQ FT	105		
703D001	TEMPORARY TRAFFIC CONTROL MARKINGS	SQ FT	3,500		
703E001	TEMPORARY TRAFFIC CONTROL LEGENDS	SQ FT	4,375		
703H000	SPECIALTY TRAFFIC CONTROL MARKINGS	SQFT	14,510		
705A000	PAVEMENT MARKERS, CLASS A-H, TYPE 1A	EACH	866		
705A030	PAVEMENT MARKERS, CLASS A-H, TYPE 2C	EACH	480		
705A032	PAVEMENT MARKERS, CLASS A-H, TYPE 1B	EACH	470		
705A037	PAVEMENT MARKERS, CLASS A-H, TYPE 2D	EACH	630		
705A038	PAVEMENT MARKERS, CLASS A-H, TYPE 2E	EACH	1200		
730A000	TRAFFIC SIGNAL AND COMPONENTS FOR INTERSECTION	LS	1		
740B000	CONSTRUCTION SIGNS	SQ FT	815		
740H000	PERMANENT SIGNS	SQ FT	300		
740D000	CHANNELIZING DRUMS	EACH	280		
740G000	BARRICADES, TYPE 1, (PORTABLE, 24" WIDE)	EACH	10		
741C010	PORTABLE CHANGEABLE SEQUENTIAL ARROW AND CHEVRON SIGN UNIT	EACH	2		
742A001	PORTABLE CHANGEABLE MESSAGE SIGN, TYPE 2	EACH	2		
750Z220	ROADWAY LIGHTING	LS	1		

BASE BID SUBTOTAL FOR NORTH DONAHUE DRIVE WIDENING PHASE 1:

(IN WORDS)